


(For Updates)
 See Project #595-118
 Five Nursing Unit
 Renovation, Building 1
 On Rack "P1"
 Drawing No. 1-P13 & 1-P14

AS-BUILT

REVISIONS	DATE:	VERIFIED BY: MECHANICAL SYSTEMS FOREMAN BOB ADAMS	DATE: 1-21-97	APPROVED: Safety & Occupational Health Manager	APPROVED: Medical Center Director	Drawing Title	Project Title	Date
				APPROVED: Chief, Environmental Management Service	APPROVED: Associate Medical Center Director	GROUND FLOOR PLAN	AIR, OXYGEN & VACUUM LINE LOCATIONS	2/10/97
				APPROVED:	APPROVED: Chief of Staff	APPROVED: Project Section	Building Number 1	Checked J.Bowers
				APPROVED:	APPROVED: Chief, Nursing Service	APPROVED: Chief, Engineering Service	Drawn R.D.Houtz	Project No.
							Location VETERANS AFFAIRS MEDICAL CENTER LEBANON, PENNSYLVANIA	Drawing No. 1-1
								Dwg. 1 of 10

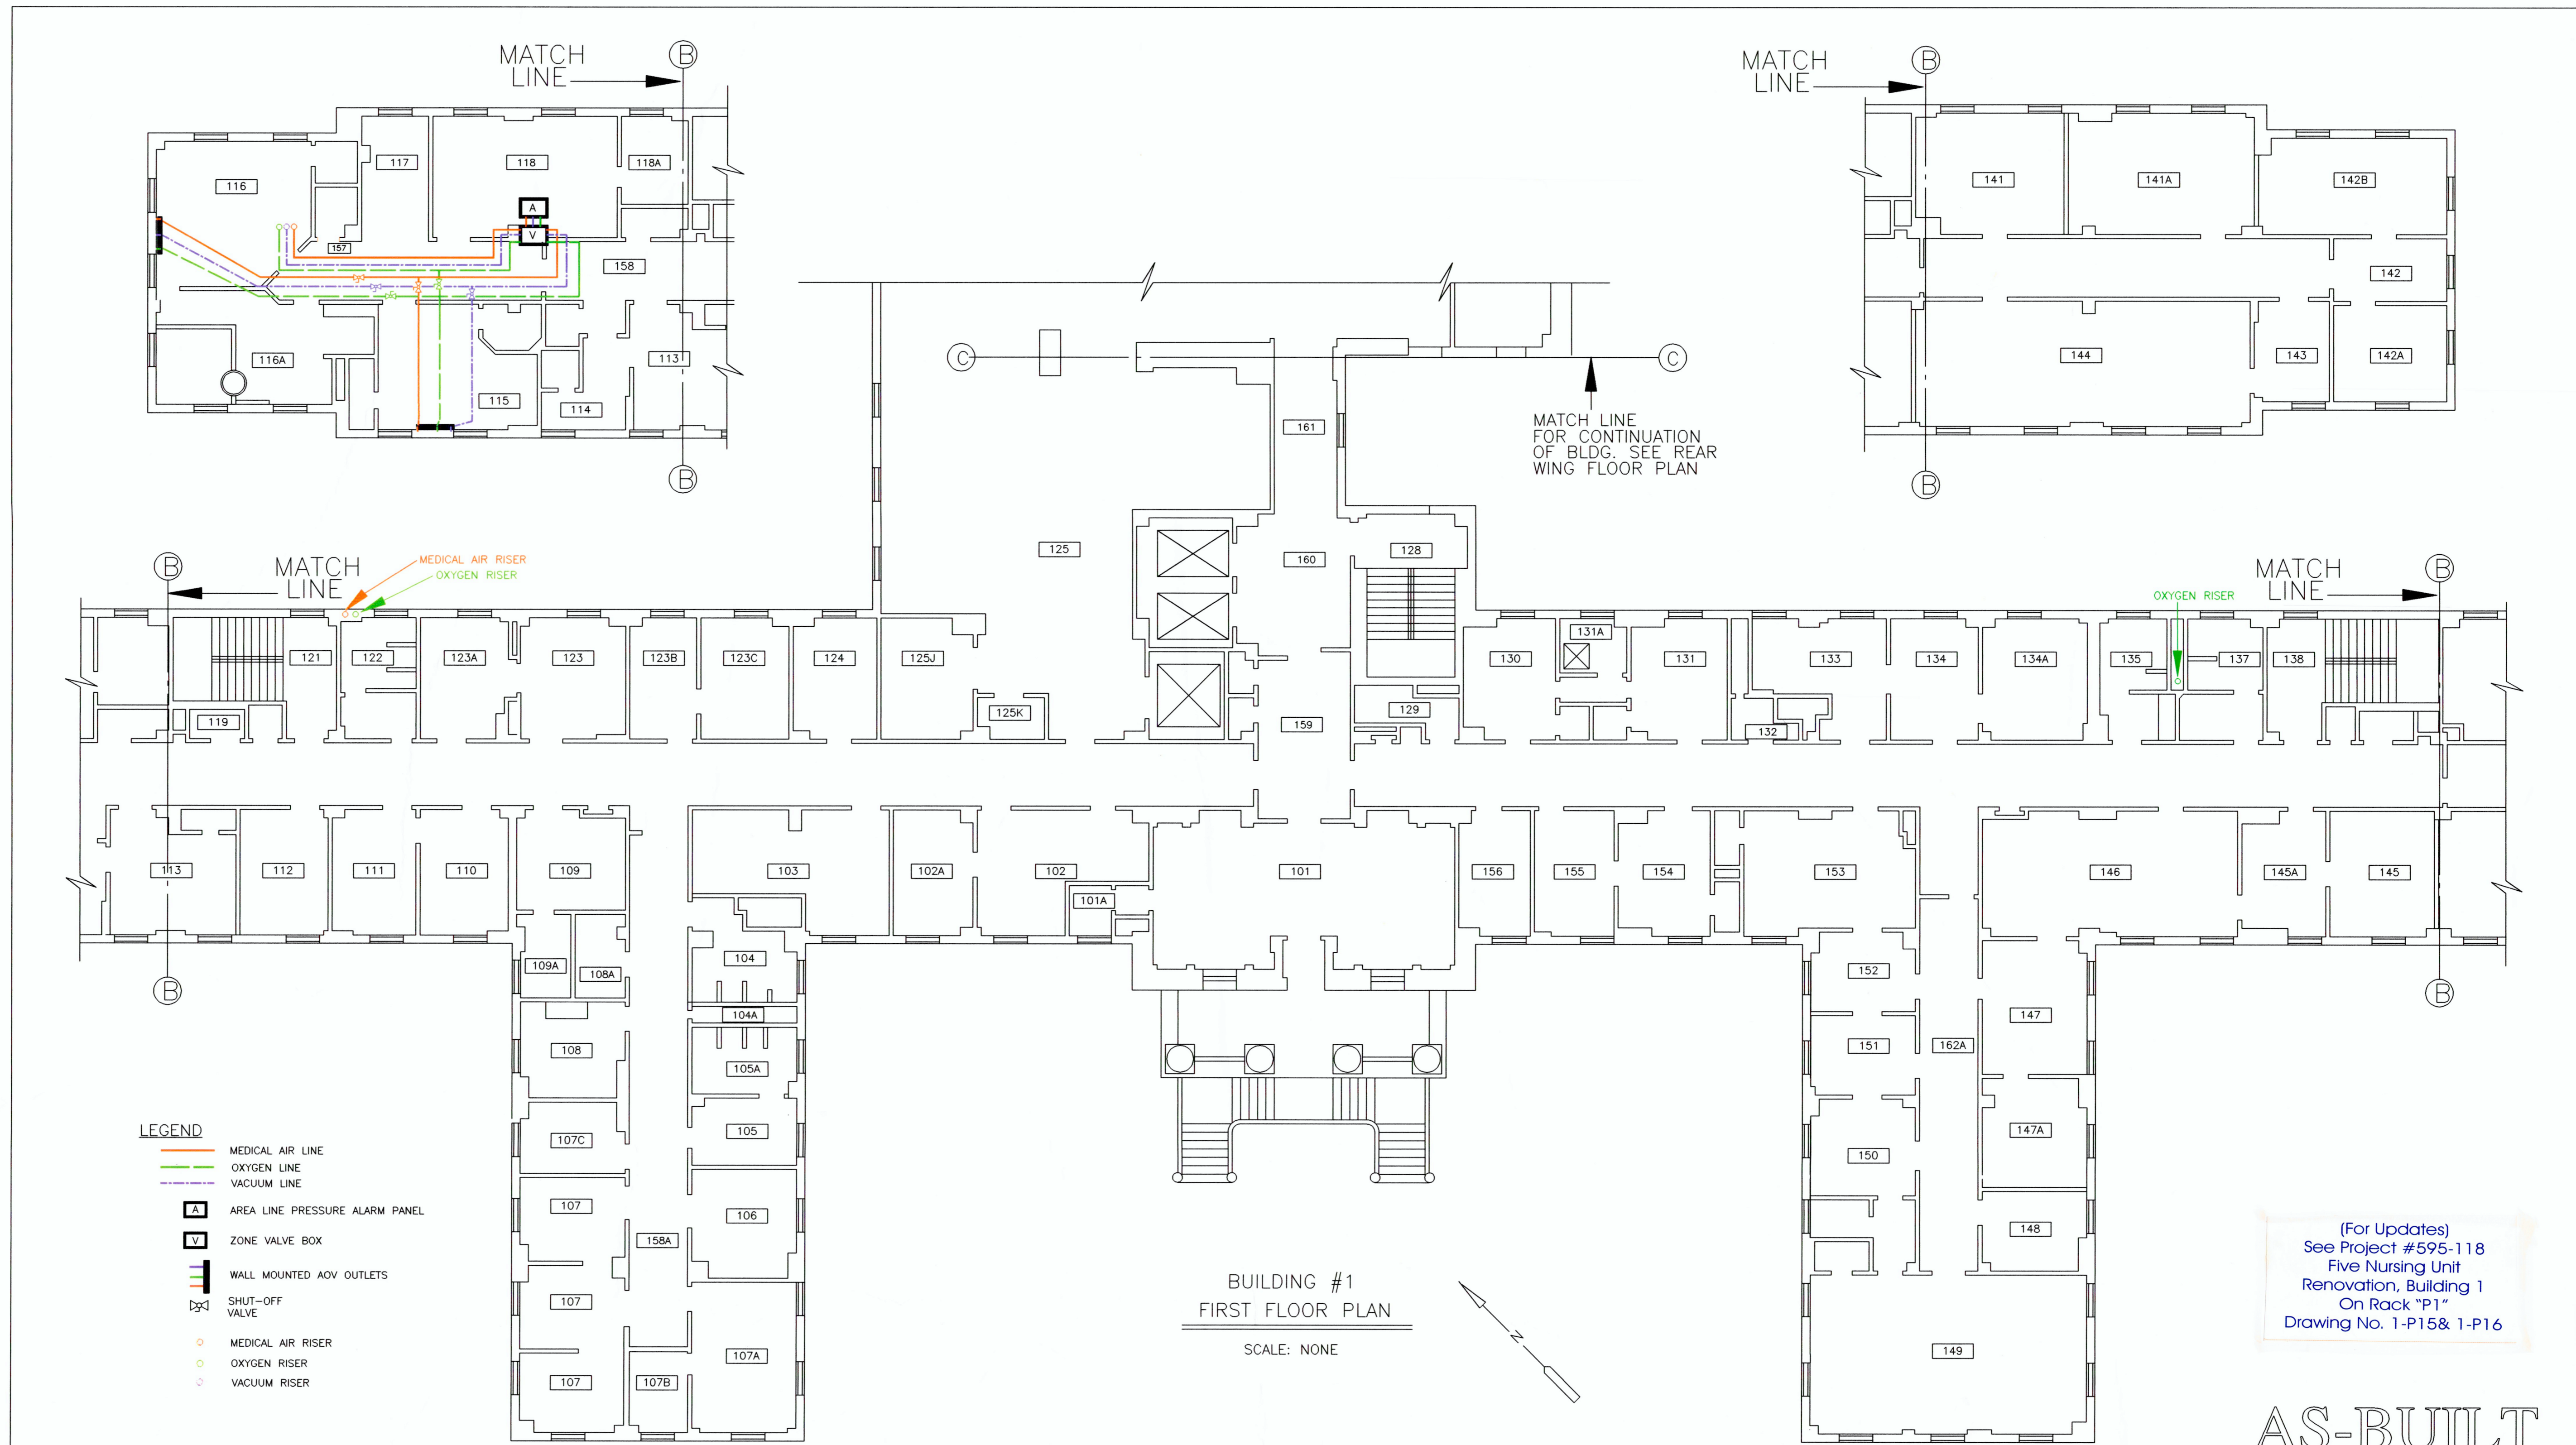


BUILDING #1
FIRST FLOOR PLAN
SCALE: NONE

(For Updates)
See Project #595-118
Five Nursing Unit
Renovation, Building 1
On Rack "P1"
Drawing No. 1-P15& 1-P16

AS-BUILT

- LEGEND**
- MEDICAL AIR LINE
 - OXYGEN LINE
 - VACUUM LINE
 - A** AREA LINE PRESSURE ALARM PANEL
 - V** ZONE VALVE BOX
 - WALL MOUNTED ADV OUTLETS
 - SHUT-OFF VALVE
 - MEDICAL AIR RISER
 - OXYGEN RISER
 - VACUUM RISER

REVISIONS	DATE:	VERIFIED BY: MECHANICAL SYSTEMS FOREMAN BOB ADAMS	DATE: 1-21-97	APPROVED: Safety & Occupational Health Manager	APPROVED: Medical Center Director	Drawing Title FIRST FLOOR PLAN	Project Title AIR, OXYGEN & VACUUM LINE LOCATIONS	Date 2/20/97
				APPROVED: Chief, Environmental Management Service	APPROVED: Associate Medical Center Director	APPROVED: Project Section	Building Number 1	Project No.
				APPROVED:	APPROVED: Chief of Staff	APPROVED: Chief, Engineering Service	Checked J.Bowers	Drawn R.D.Houtz
				APPROVED:	APPROVED: Chief, Nursing Service	Location VETERANS AFFAIRS MEDICAL CENTER LEBANON, PENNSYLVANIA	Drawing No. 1-2	Dwg. 2 Of 10

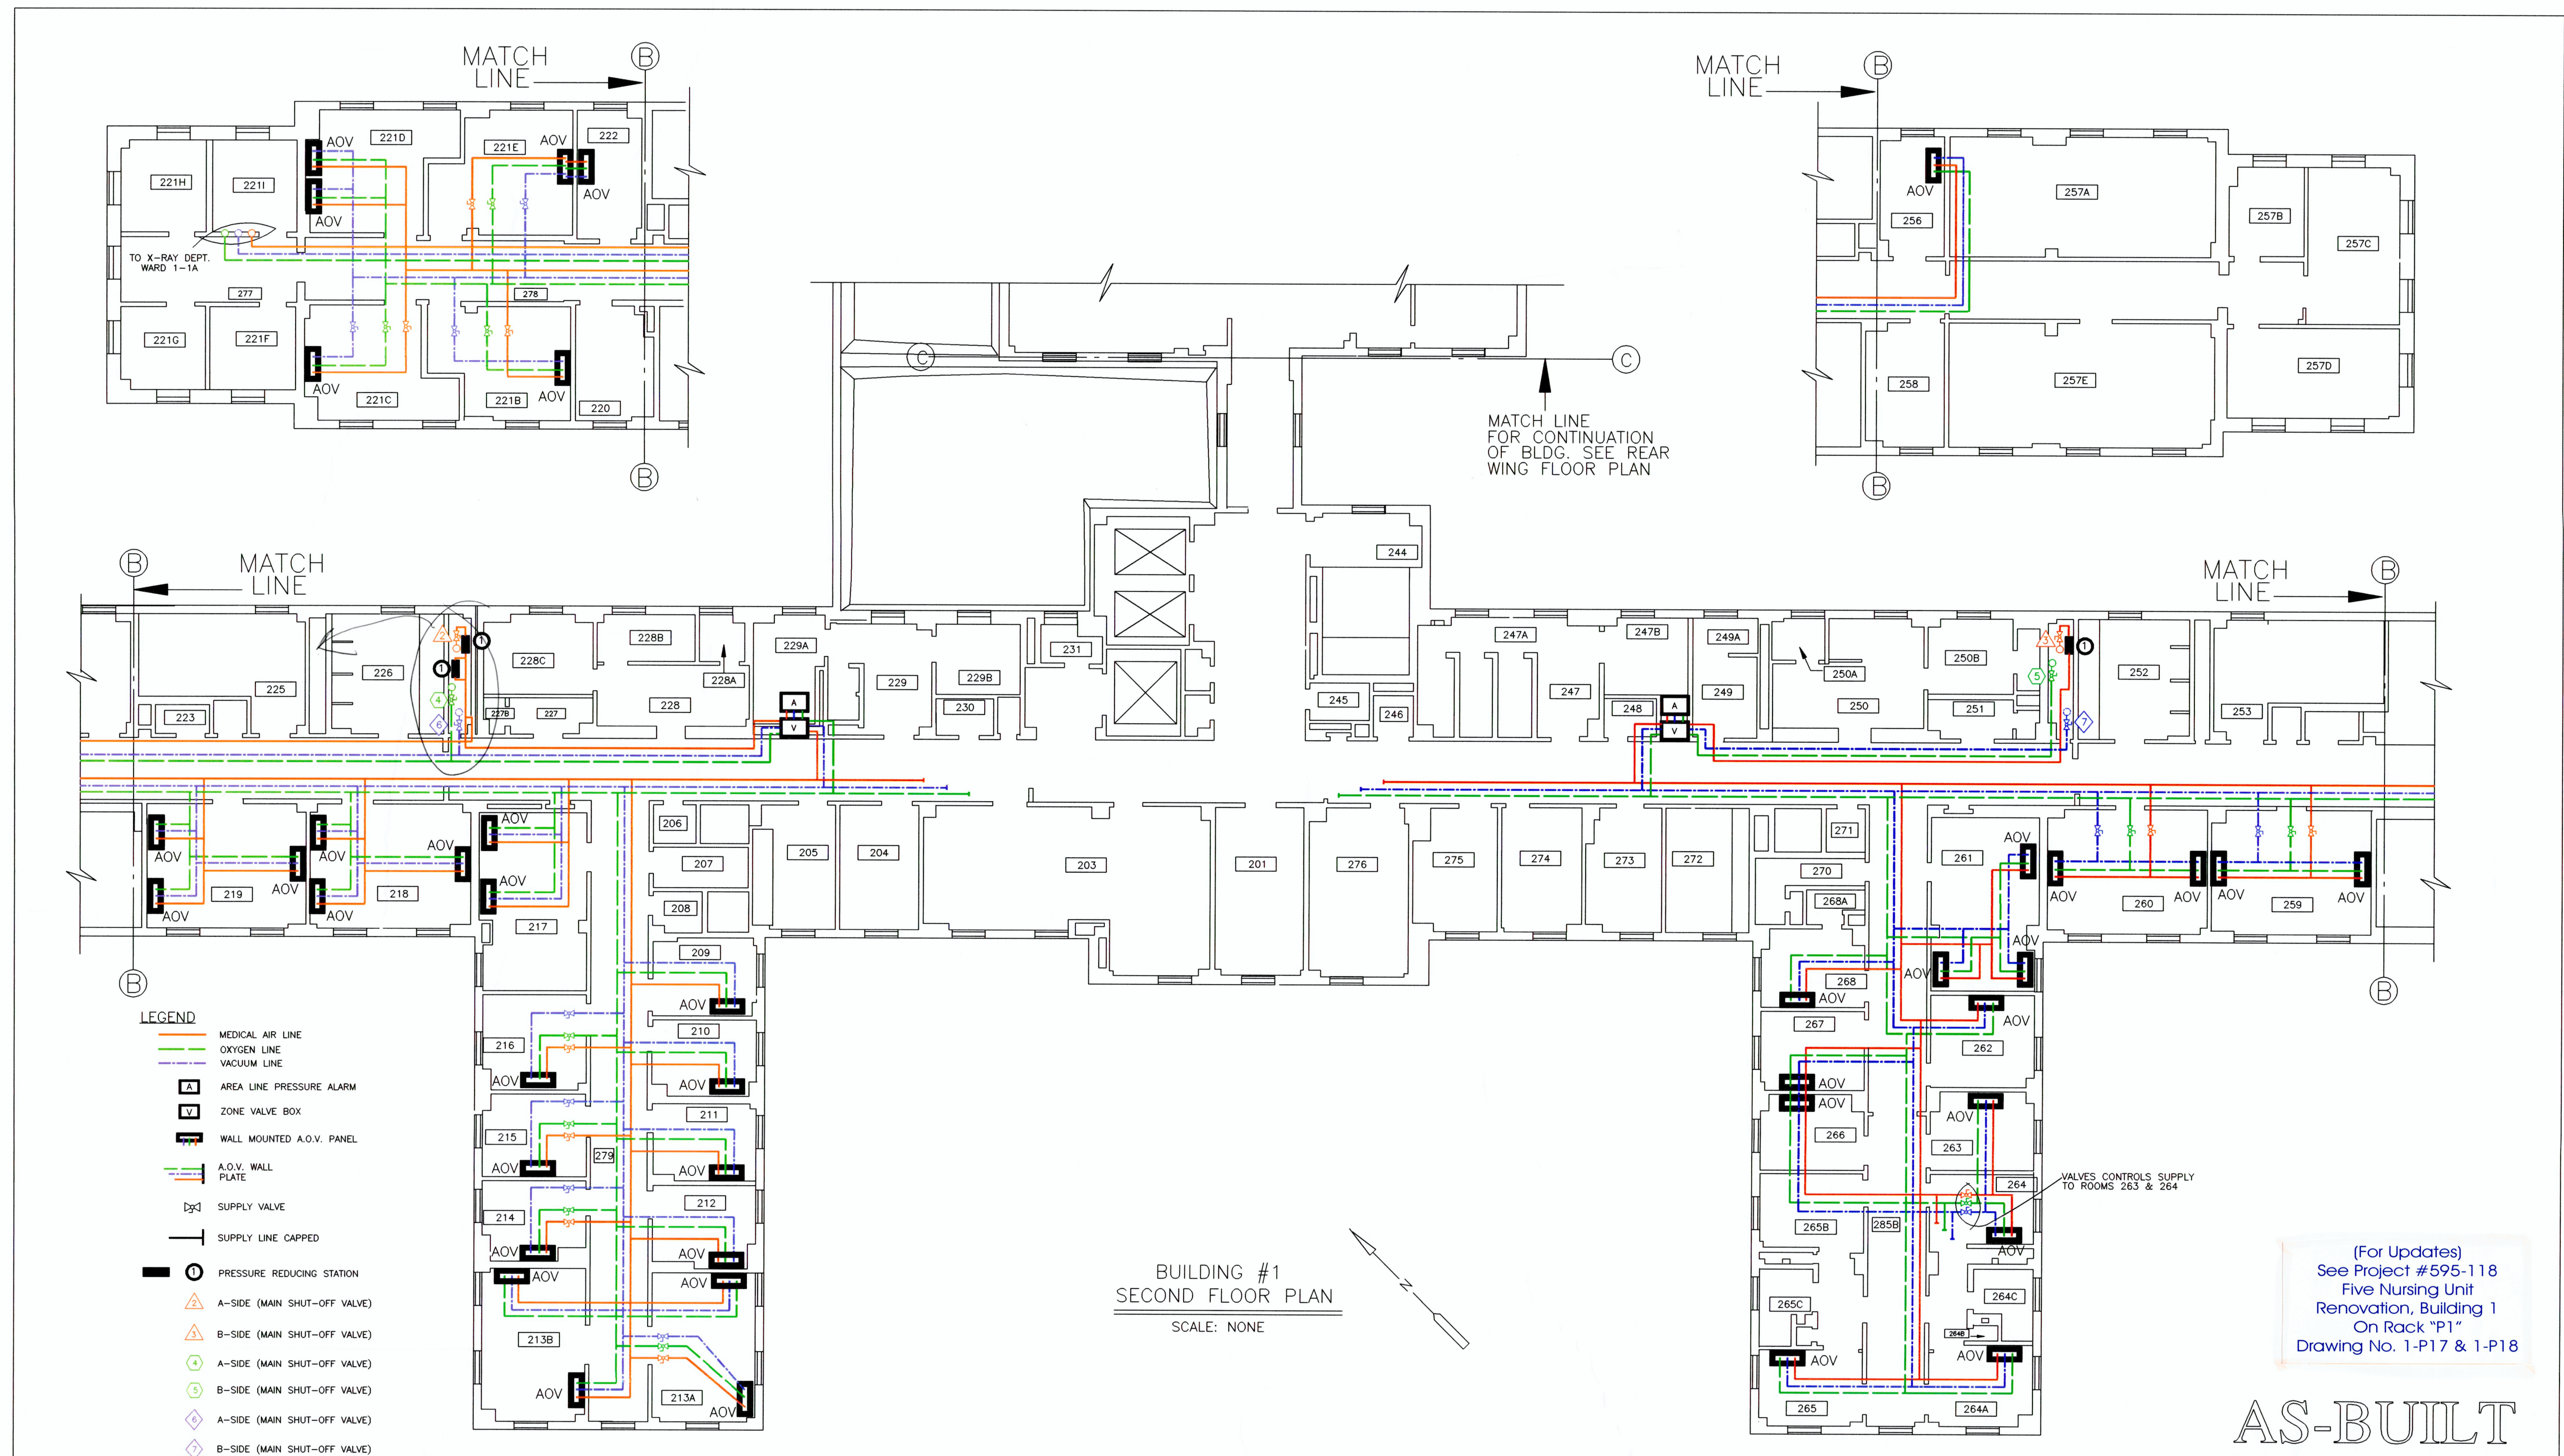

- LEGEND**
- MEDICAL AIR LINE
 - OXYGEN LINE
 - VACUUM LINE
 - A AREA LINE PRESSURE ALARM
 - V ZONE VALVE BOX
 - W WALL MOUNTED A.O.V. PANEL
 - P A.O.V. WALL PLATE
 - S SUPPLY VALVE
 - C SUPPLY LINE CAPPED
 - P PRESSURE REDUCING STATION
 - A A-SIDE (MAIN SHUT-OFF VALVE)
 - B B-SIDE (MAIN SHUT-OFF VALVE)
 - A A-SIDE (MAIN SHUT-OFF VALVE)
 - B B-SIDE (MAIN SHUT-OFF VALVE)
 - A A-SIDE (MAIN SHUT-OFF VALVE)
 - B B-SIDE (MAIN SHUT-OFF VALVE)

BUILDING #1
SECOND FLOOR PLAN
SCALE: NONE


(For Updates)
See Project #595-118
Five Nursing Unit
Renovation, Building 1
On Rack "P1"
Drawing No. 1-P17 & 1-P18

AS-BUILT


APPROVED: Safety & Occupational Health Manager	APPROVED: Medical Center Director	Drawing Title	Project Title
APPROVED: Chief, Environmental Management Service	APPROVED: Associate Medical Center Director	SECOND FLOOR PLAN	AIR, OXYGEN & VACUUM LINE LOCATIONS
APPROVED:	APPROVED: Chief of Staff	APPROVED: Project Section	Building Number 1
APPROVED:	APPROVED: Chief, Nursing Service	APPROVED: Chief, Engineering Service	Checked J.Bowers
APPROVED:			Drawn R.D.Houtz
REVISIONS	DATE:	VERIFIED BY: MECHANICAL SYSTEMS FOREMAN BOB ADAMS	DATE: 1-21-97

LEGEND


- OXYGEN LINE
- - - OXYGEN LINE (UNDERGROUND)
- ○ ○ OXYGEN LEVEL GAUGES

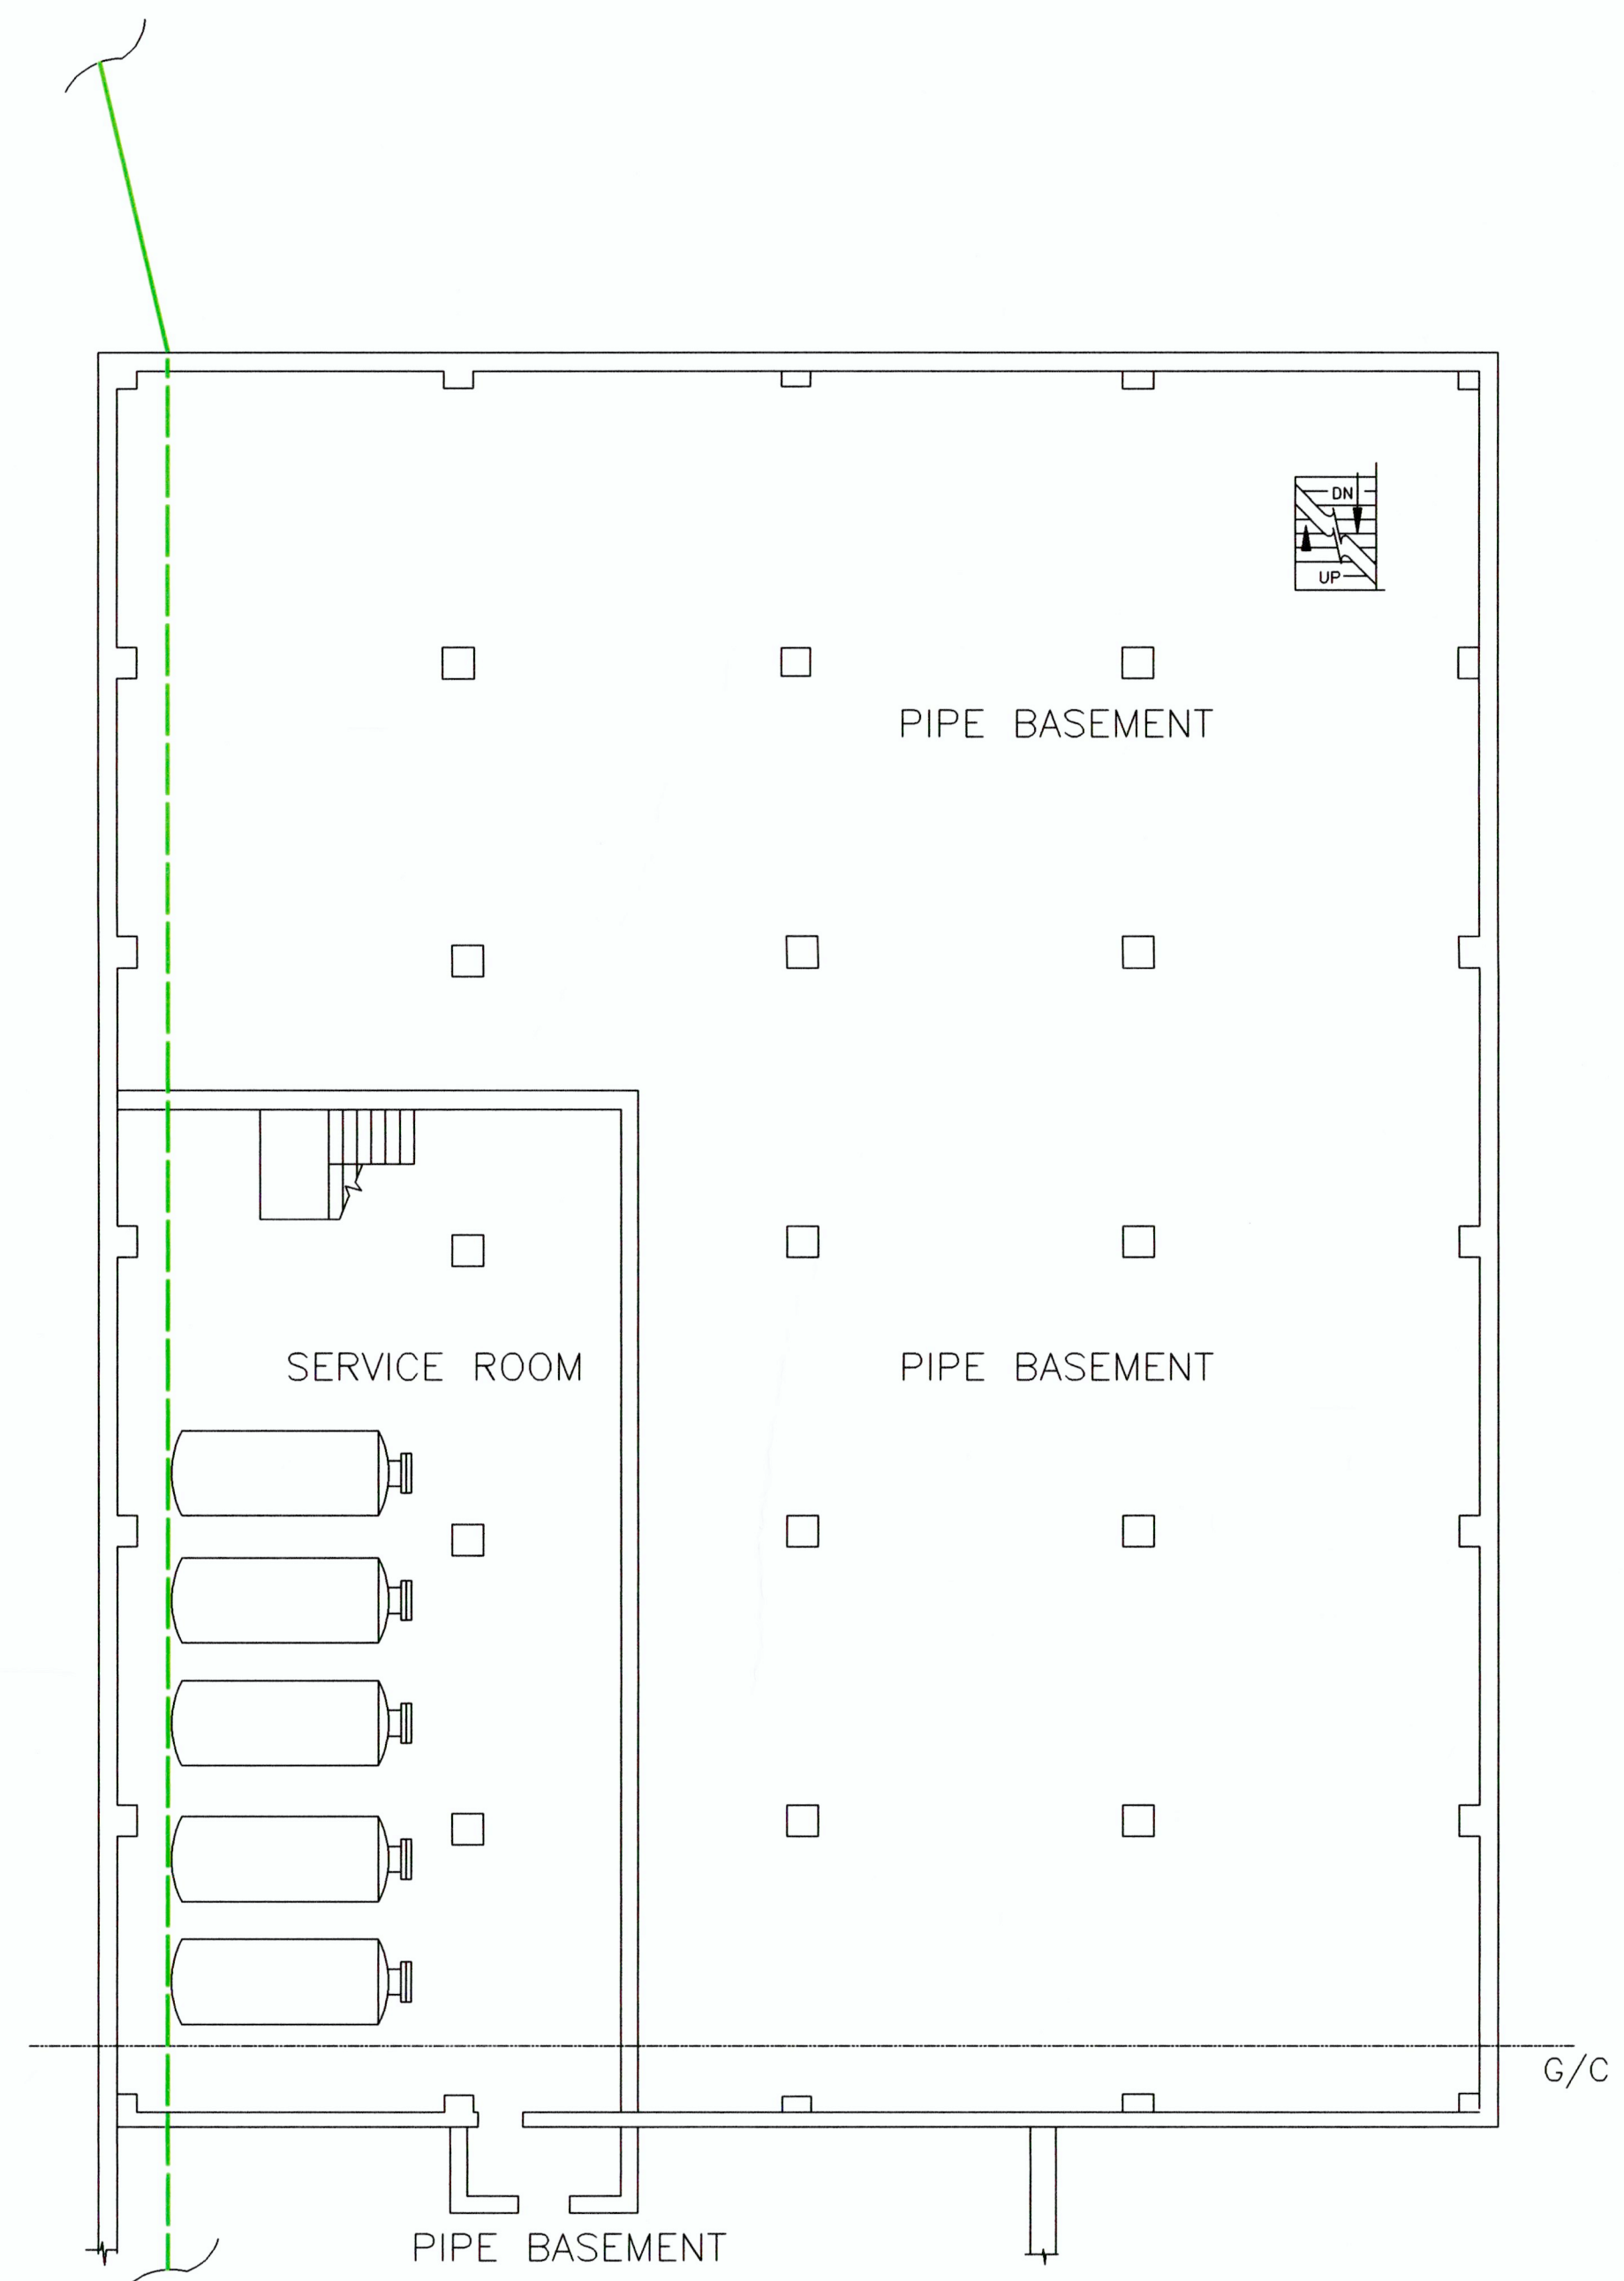


BLDG. #1 ANNEX.
PIPE BASMT FLOOR PLAN
SCALE: N.T.S.

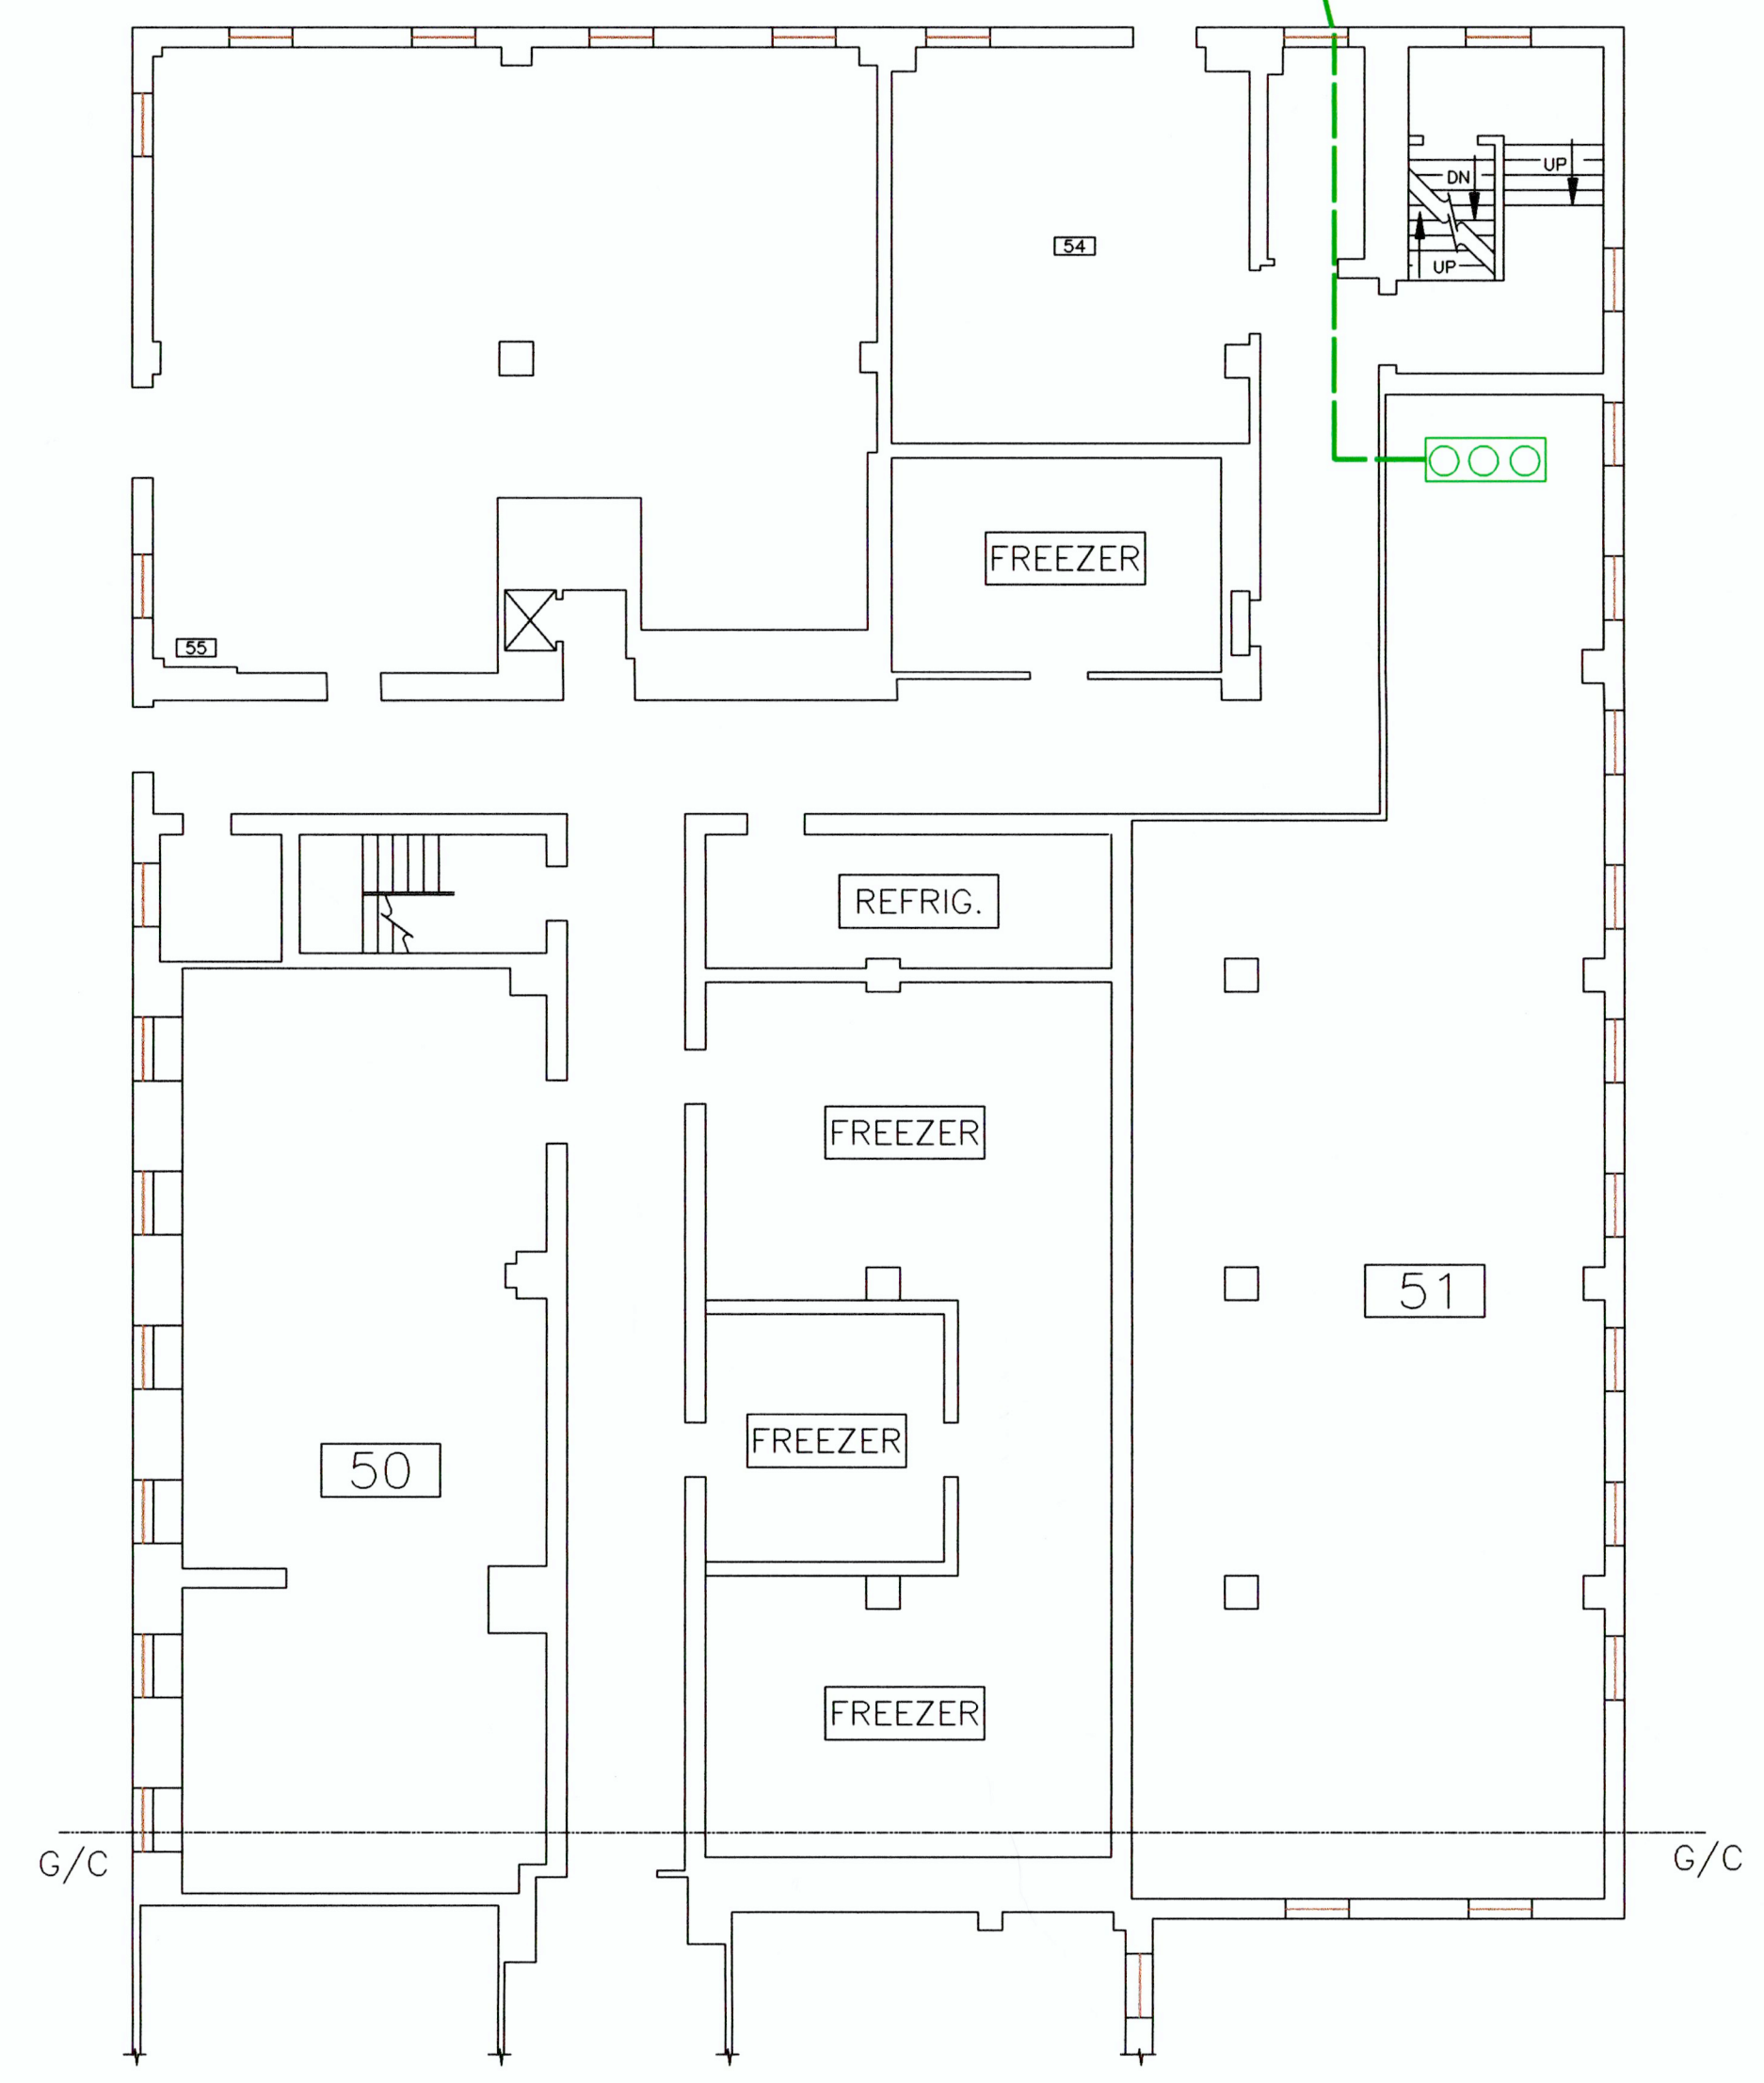

BLDG. #1 ANNEX.
GROUND FLOOR PLAN
SCALE: N.T.S.

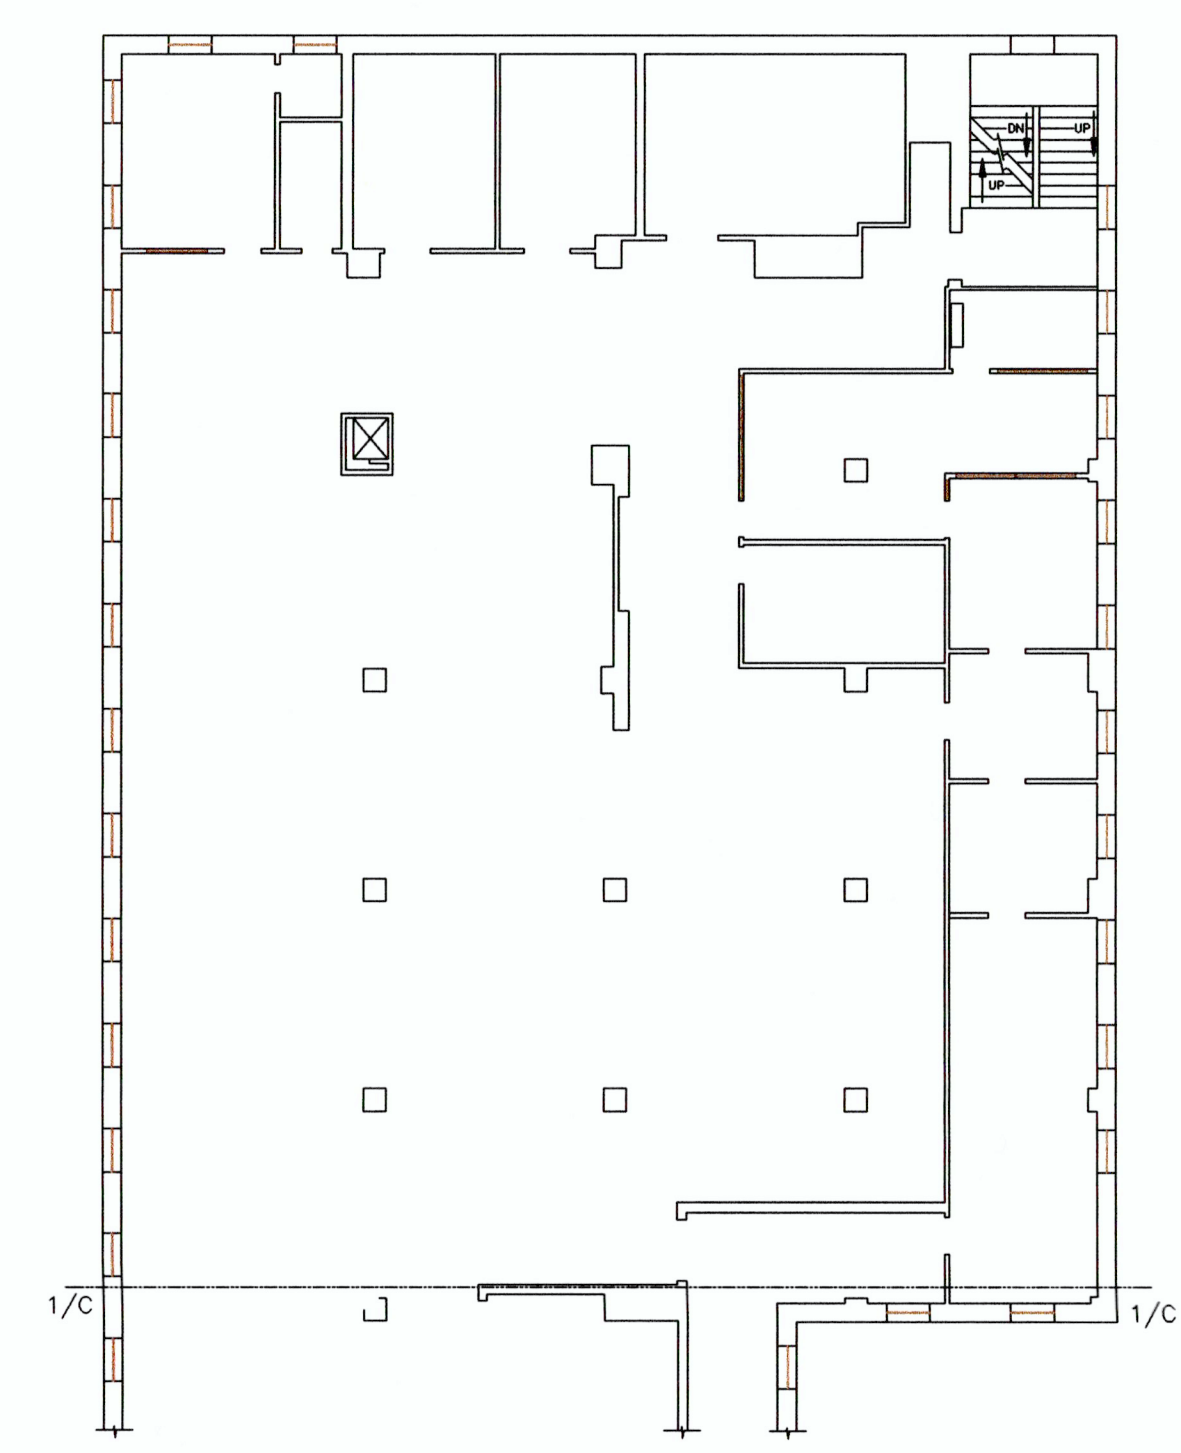

BLDG. #1 ANNEX.
FIRST FLOOR PLAN
SCALE: N.T.S.

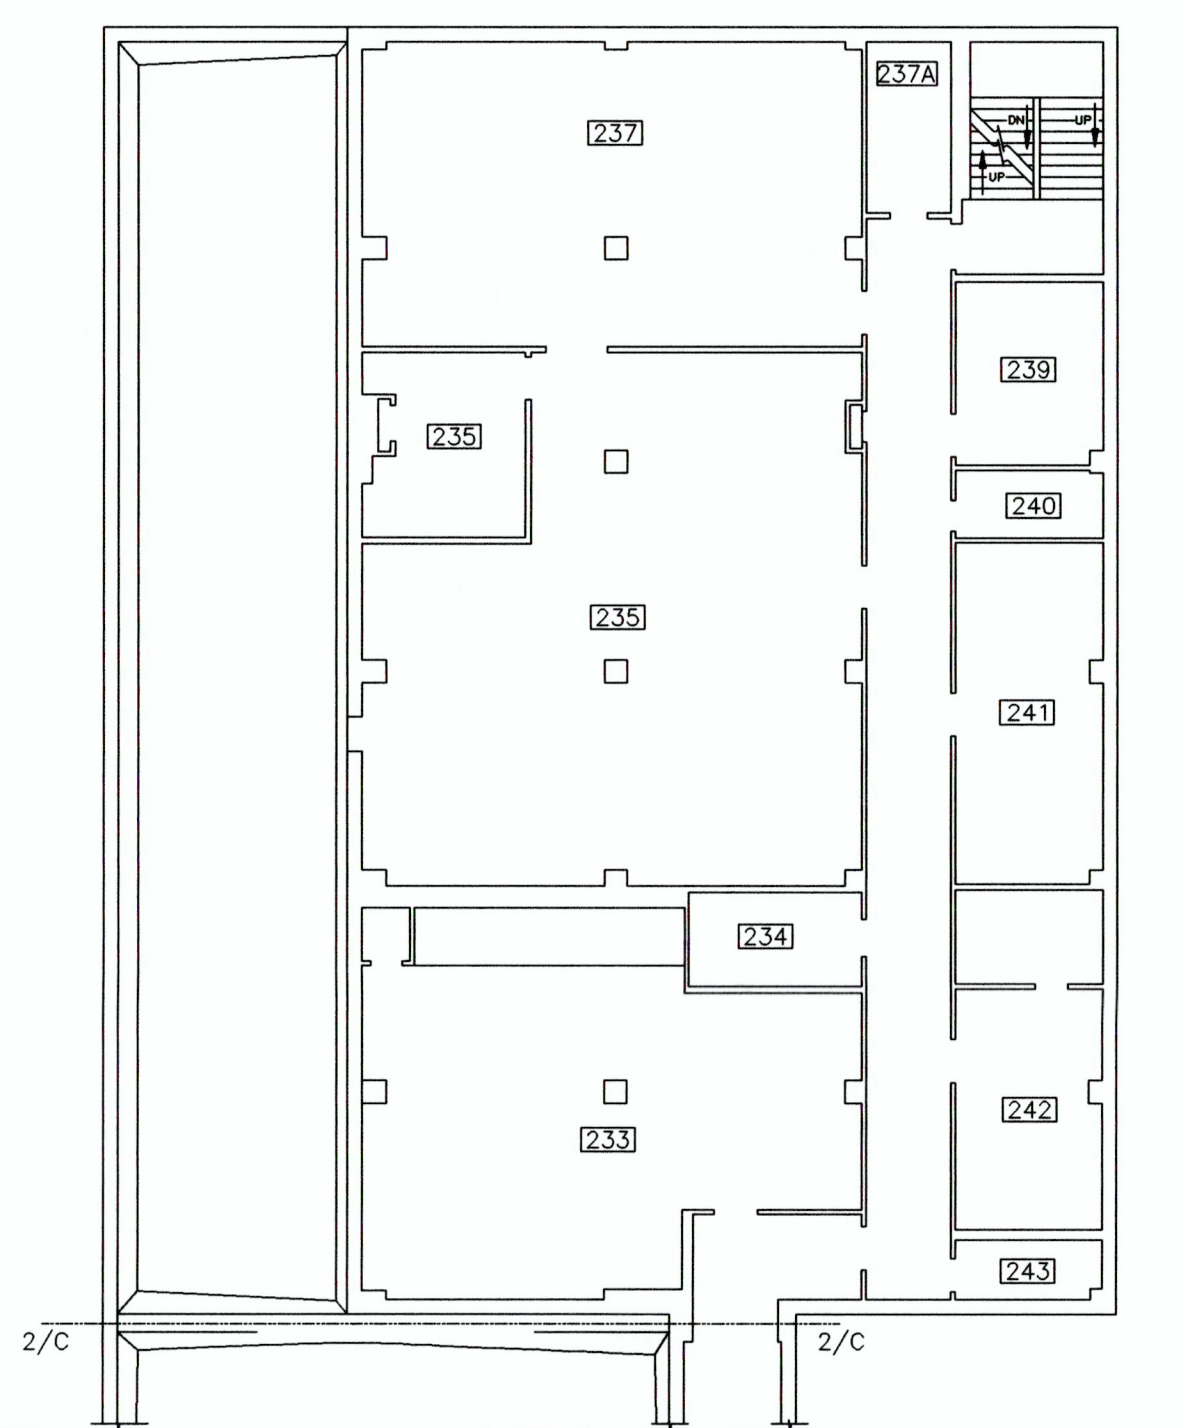


BLDG. #1 ANNEX.
SECOND FLOOR PLAN
SCALE: N.T.S.

AS-BUILT

REVISIONS	DATE:	VERIFIED BY: MECHANICAL SYSTEMS FOREMAN BOB ADAMS	DATE: 1-21-97	APPROVED: Safety & Occupational Health Manager	APPROVED: Medical Center Director	Drawing Title PIPE BASEMENT, GROUND, 1ST AND 2ND ANNEX. FLOOR PLANS	Project Title AIR, OXYGEN & VACUUM LINE LOCATION		Date 2/20/97				
				APPROVED: Chief, Environmental Management Service	APPROVED: Associate Medical Center Director					Building Number 1	Checked J.Bowers	Drawn R.D.Houtz	
				APPROVED:	APPROVED: Chief of Staff								Drawing No. 1-4
				APPROVED:	APPROVED: Chief, Nursing Service								
				APPROVED: Project Section	APPROVED: Chief, Engineering Service	Dwg. 4 of 10							

1A0V2ANN

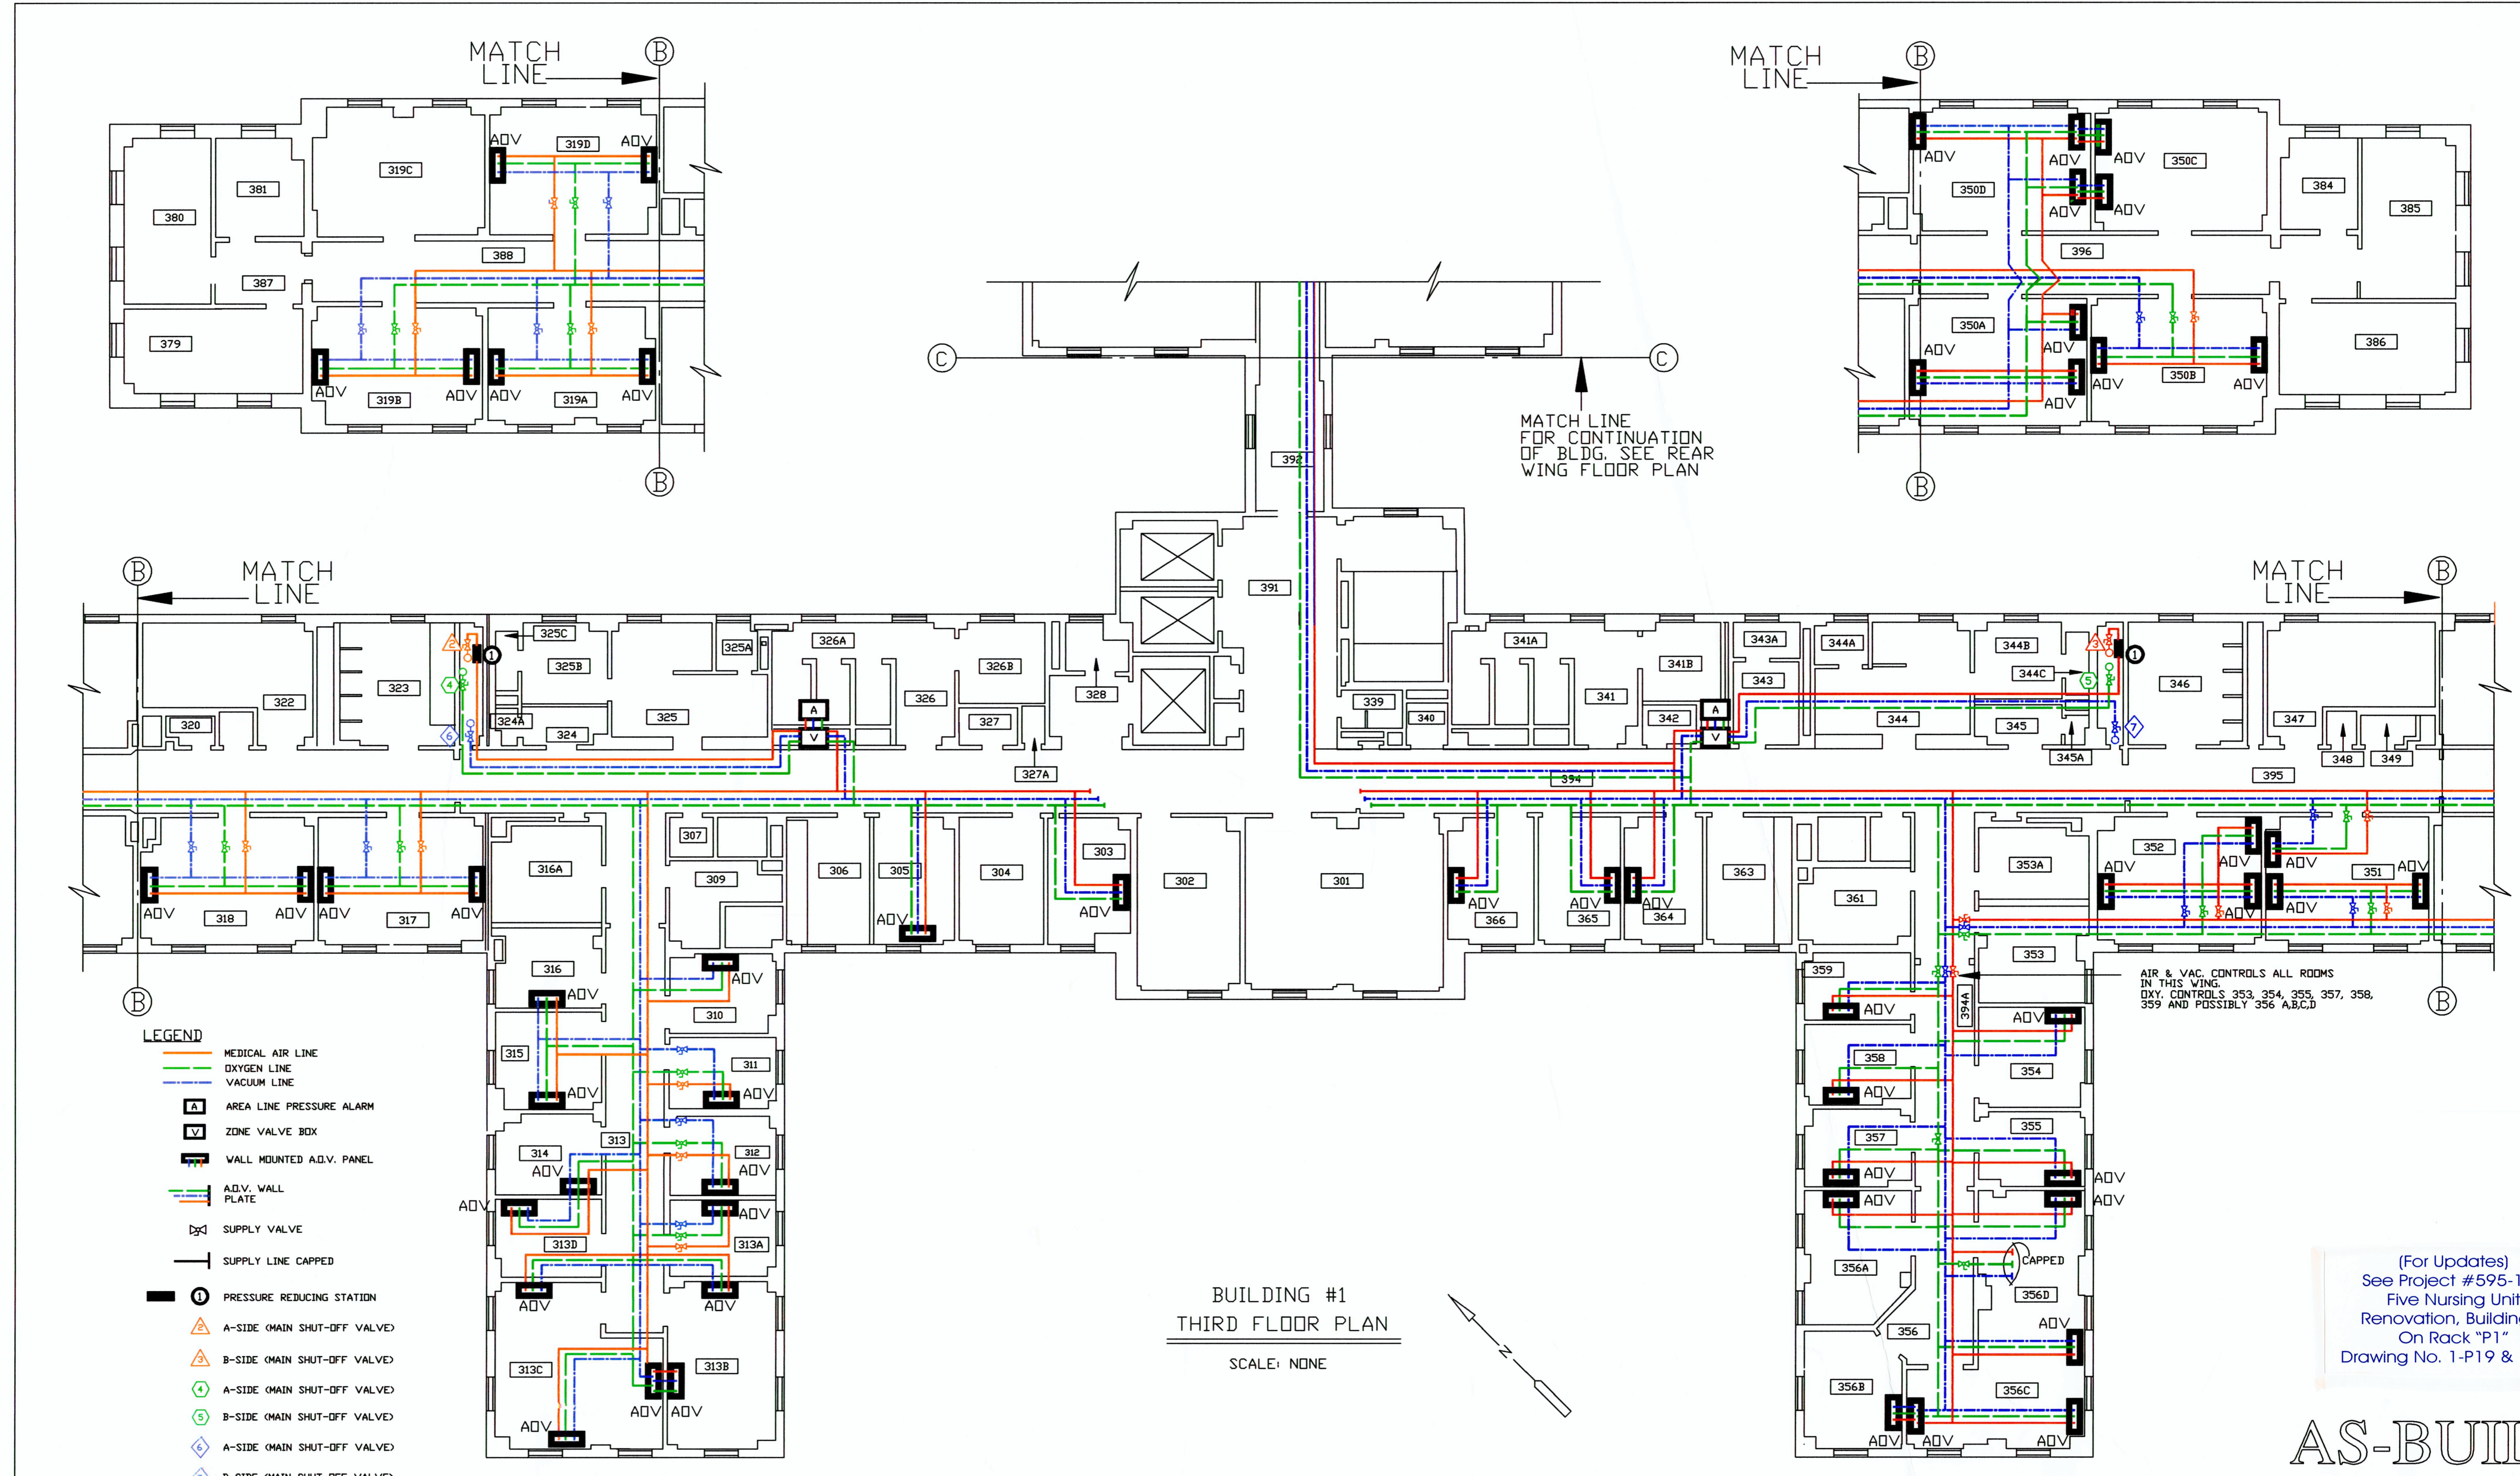


BUILDING #1
THIRD FLOOR PLAN
SCALE: NONE

(For Updates)
See Project #595-118
Five Nursing Unit
Renovation, Building 1
On Rack "P1"
Drawing No. 1-P19 & 1-P21

AS-BUILT

REVISIONS	DATE:	VERIFIED BY: MECHANICAL SYSTEMS FOREMAN BOB ADAMS	DATE: 1-21-97	APPROVED: Safety & Occupational Health Manager	APPROVED: Medical Center Director	Drawing Title THIRD FLOOR PLAN	Project Title AIR, OXYGEN & VACUUM LINE LOCATION		Date 2/21/97	
				APPROVED: Chief, Environmental Management Service	APPROVED: Associate Medical Center Director		Project No.			
				APPROVED:	APPROVED: Chief of Staff		Building Number 1	Checked J.Bowers	Drawn R.D.Houtz	Drawing No. 1-5
				APPROVED:	APPROVED: Chief, Nursing Service		APPROVED: Chief, Engineering Service	Location VETERANS AFFAIRS MEDICAL CENTER LEBANON, PENNSYLVANIA		Dwg. 5 of 10

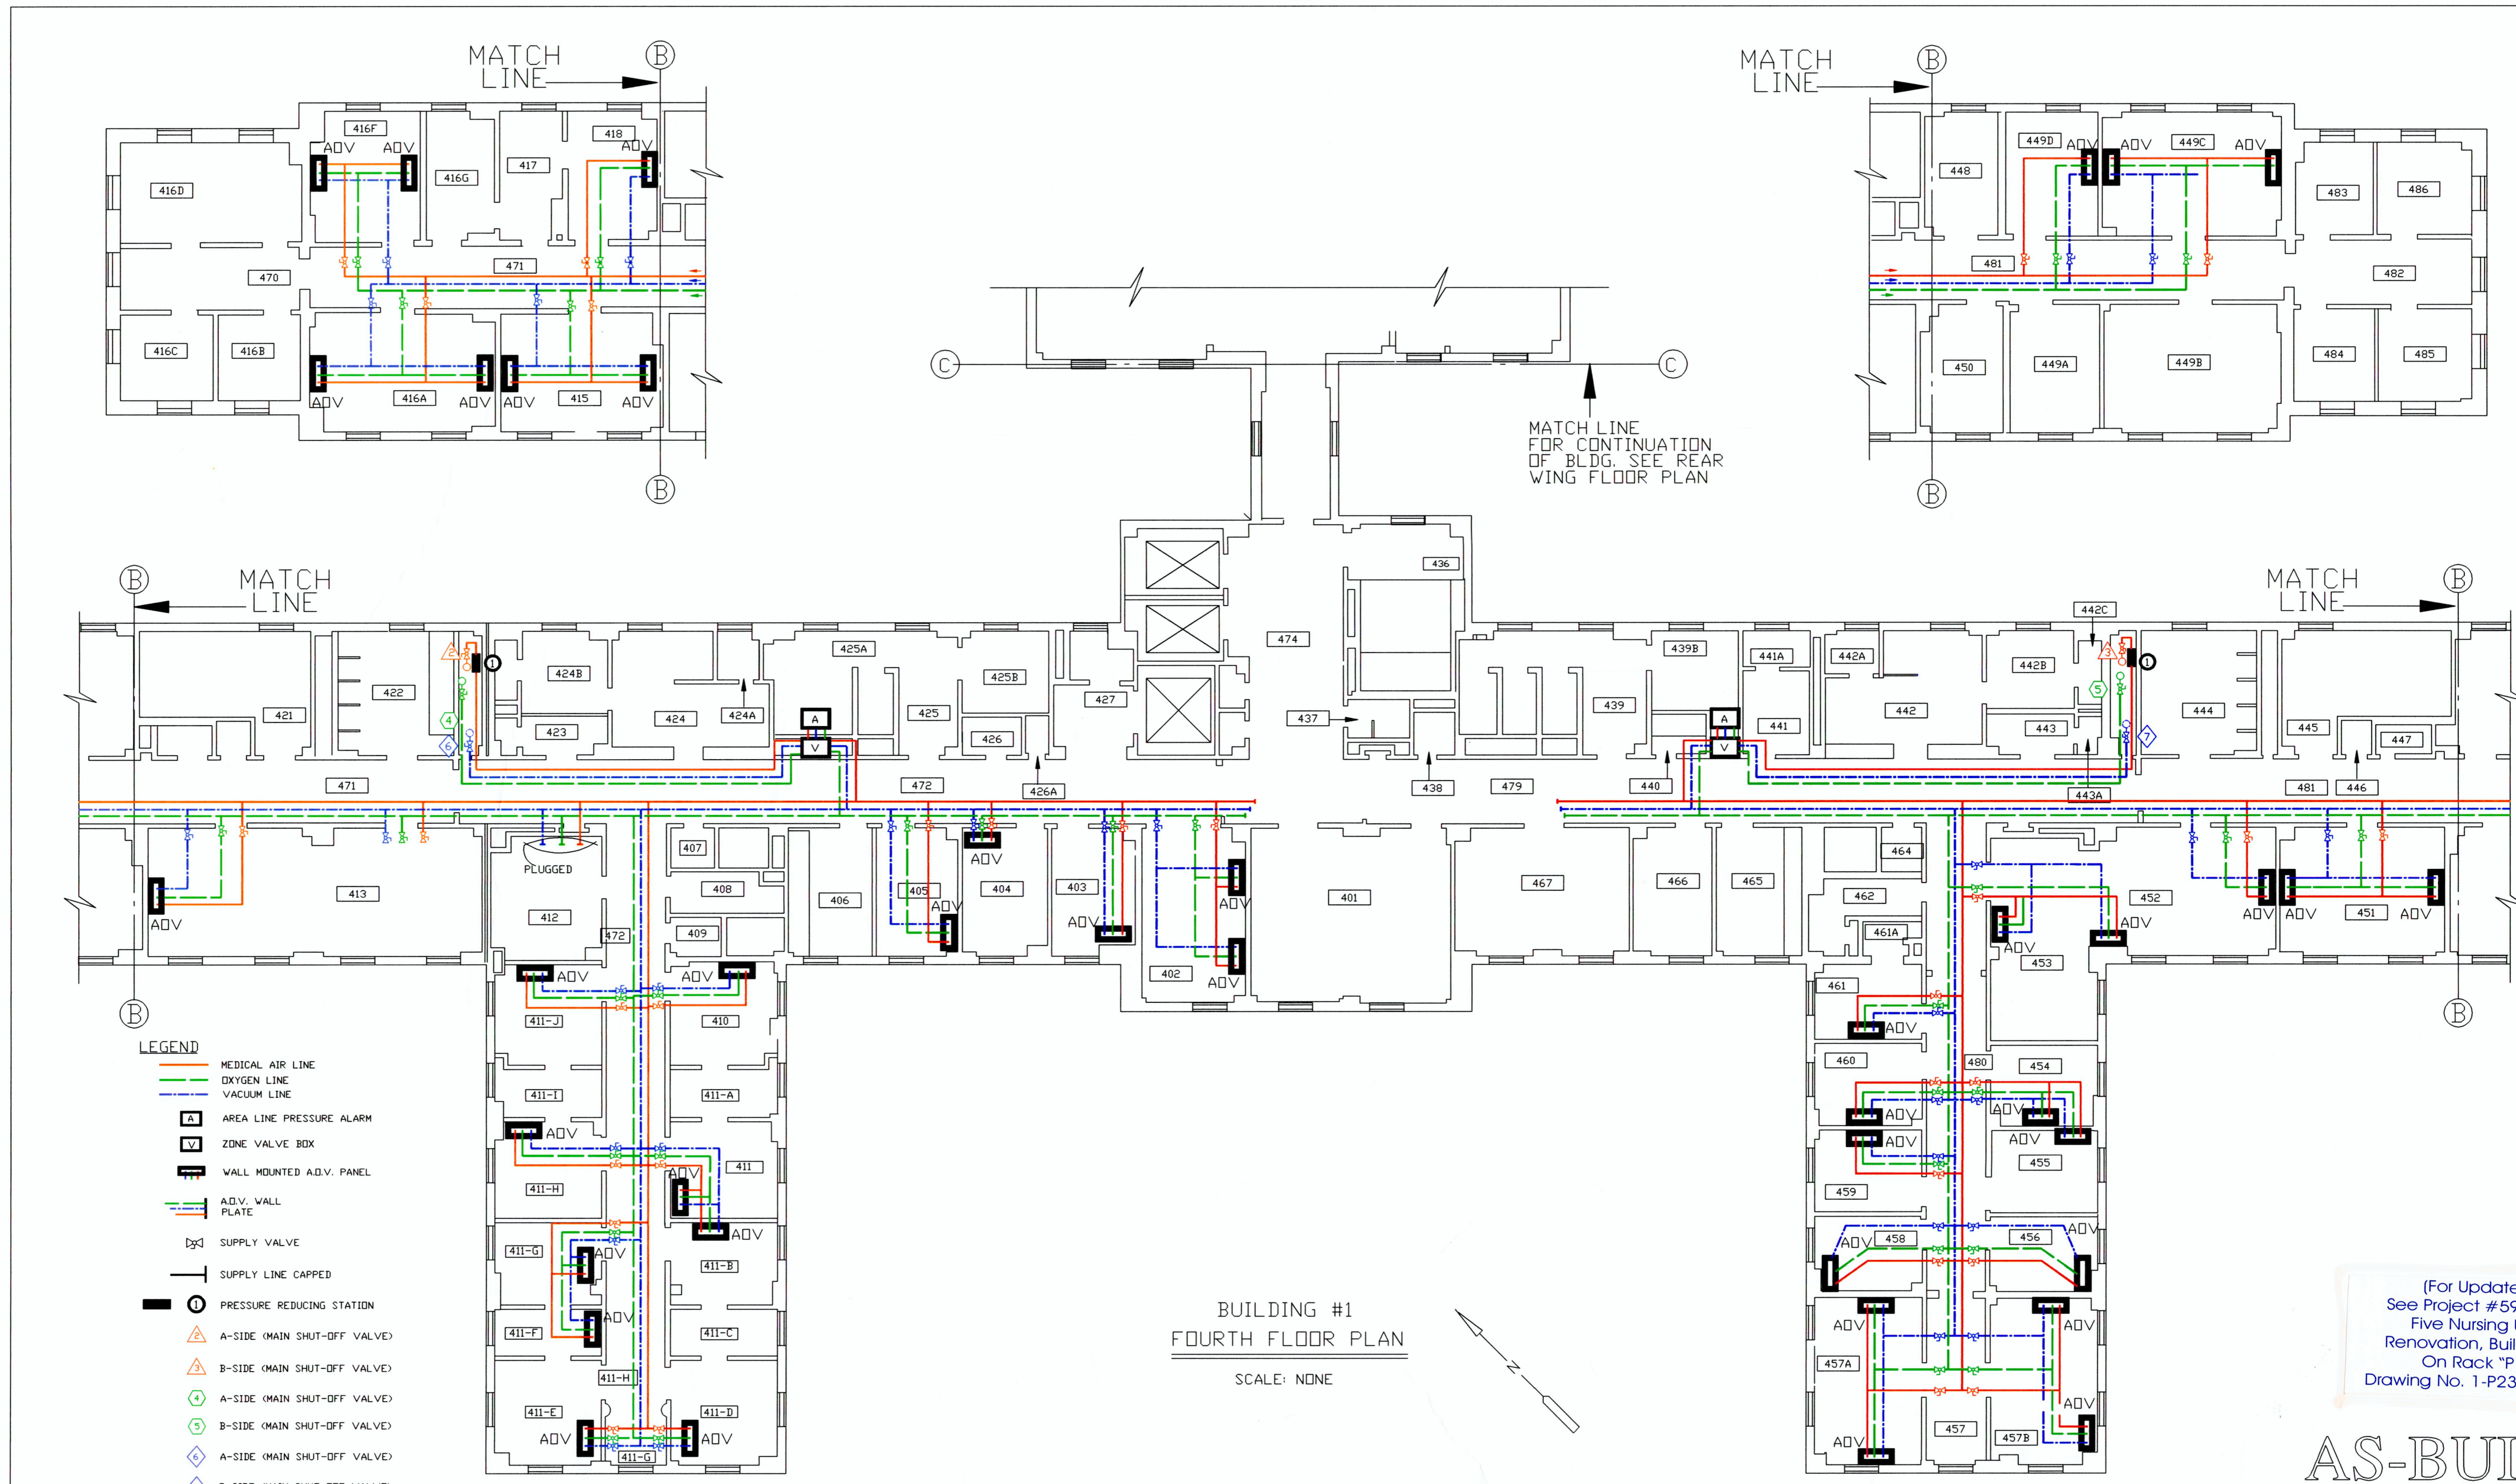


(For Updates)
See Project #595-118
Five Nursing Unit
Renovation, Building 1
On Rack "P1"
Drawing No. 1-P23 & 1-P25

AS-BUILT

BUILDING #1
FOURTH FLOOR PLAN
SCALE: NONE

REVISIONS 1 REMOVE WALL AT 413/414 AND 416D/416E AND 5 ADV PANELS IN 413/414 DATE: 1-8-97	VERIFIED BY: MECHANICAL SYSTEMS FOREMAN BOB ADAMS	DATE: 1-21-97	APPROVED: Safety & Occupational Health Manager	APPROVED: Medical Center Director	Drawing Title FOURTH FLOOR PLAN	Project Title AIR, OXYGEN & VACUUM LINE LOCATION	Date 2/21/97	
			APPROVED: Chief, Environmental Management Service	APPROVED: Associate Medical Center Director			Project No.	
APPROVED:	APPROVED: Chief of Staff	APPROVED: Project Section	Building Number 1	Checked J.Bowers	Drawn R.D.Houtz	Drawing No. 1-6	Location VETERANS AFFAIRS MEDICAL CENTER LEBANON, PENNSYLVANIA	Dwg. 6 OF 10
APPROVED:	APPROVED: Chief, Nursing Service	APPROVED: Chief, Engineering Service						

1-4ADV

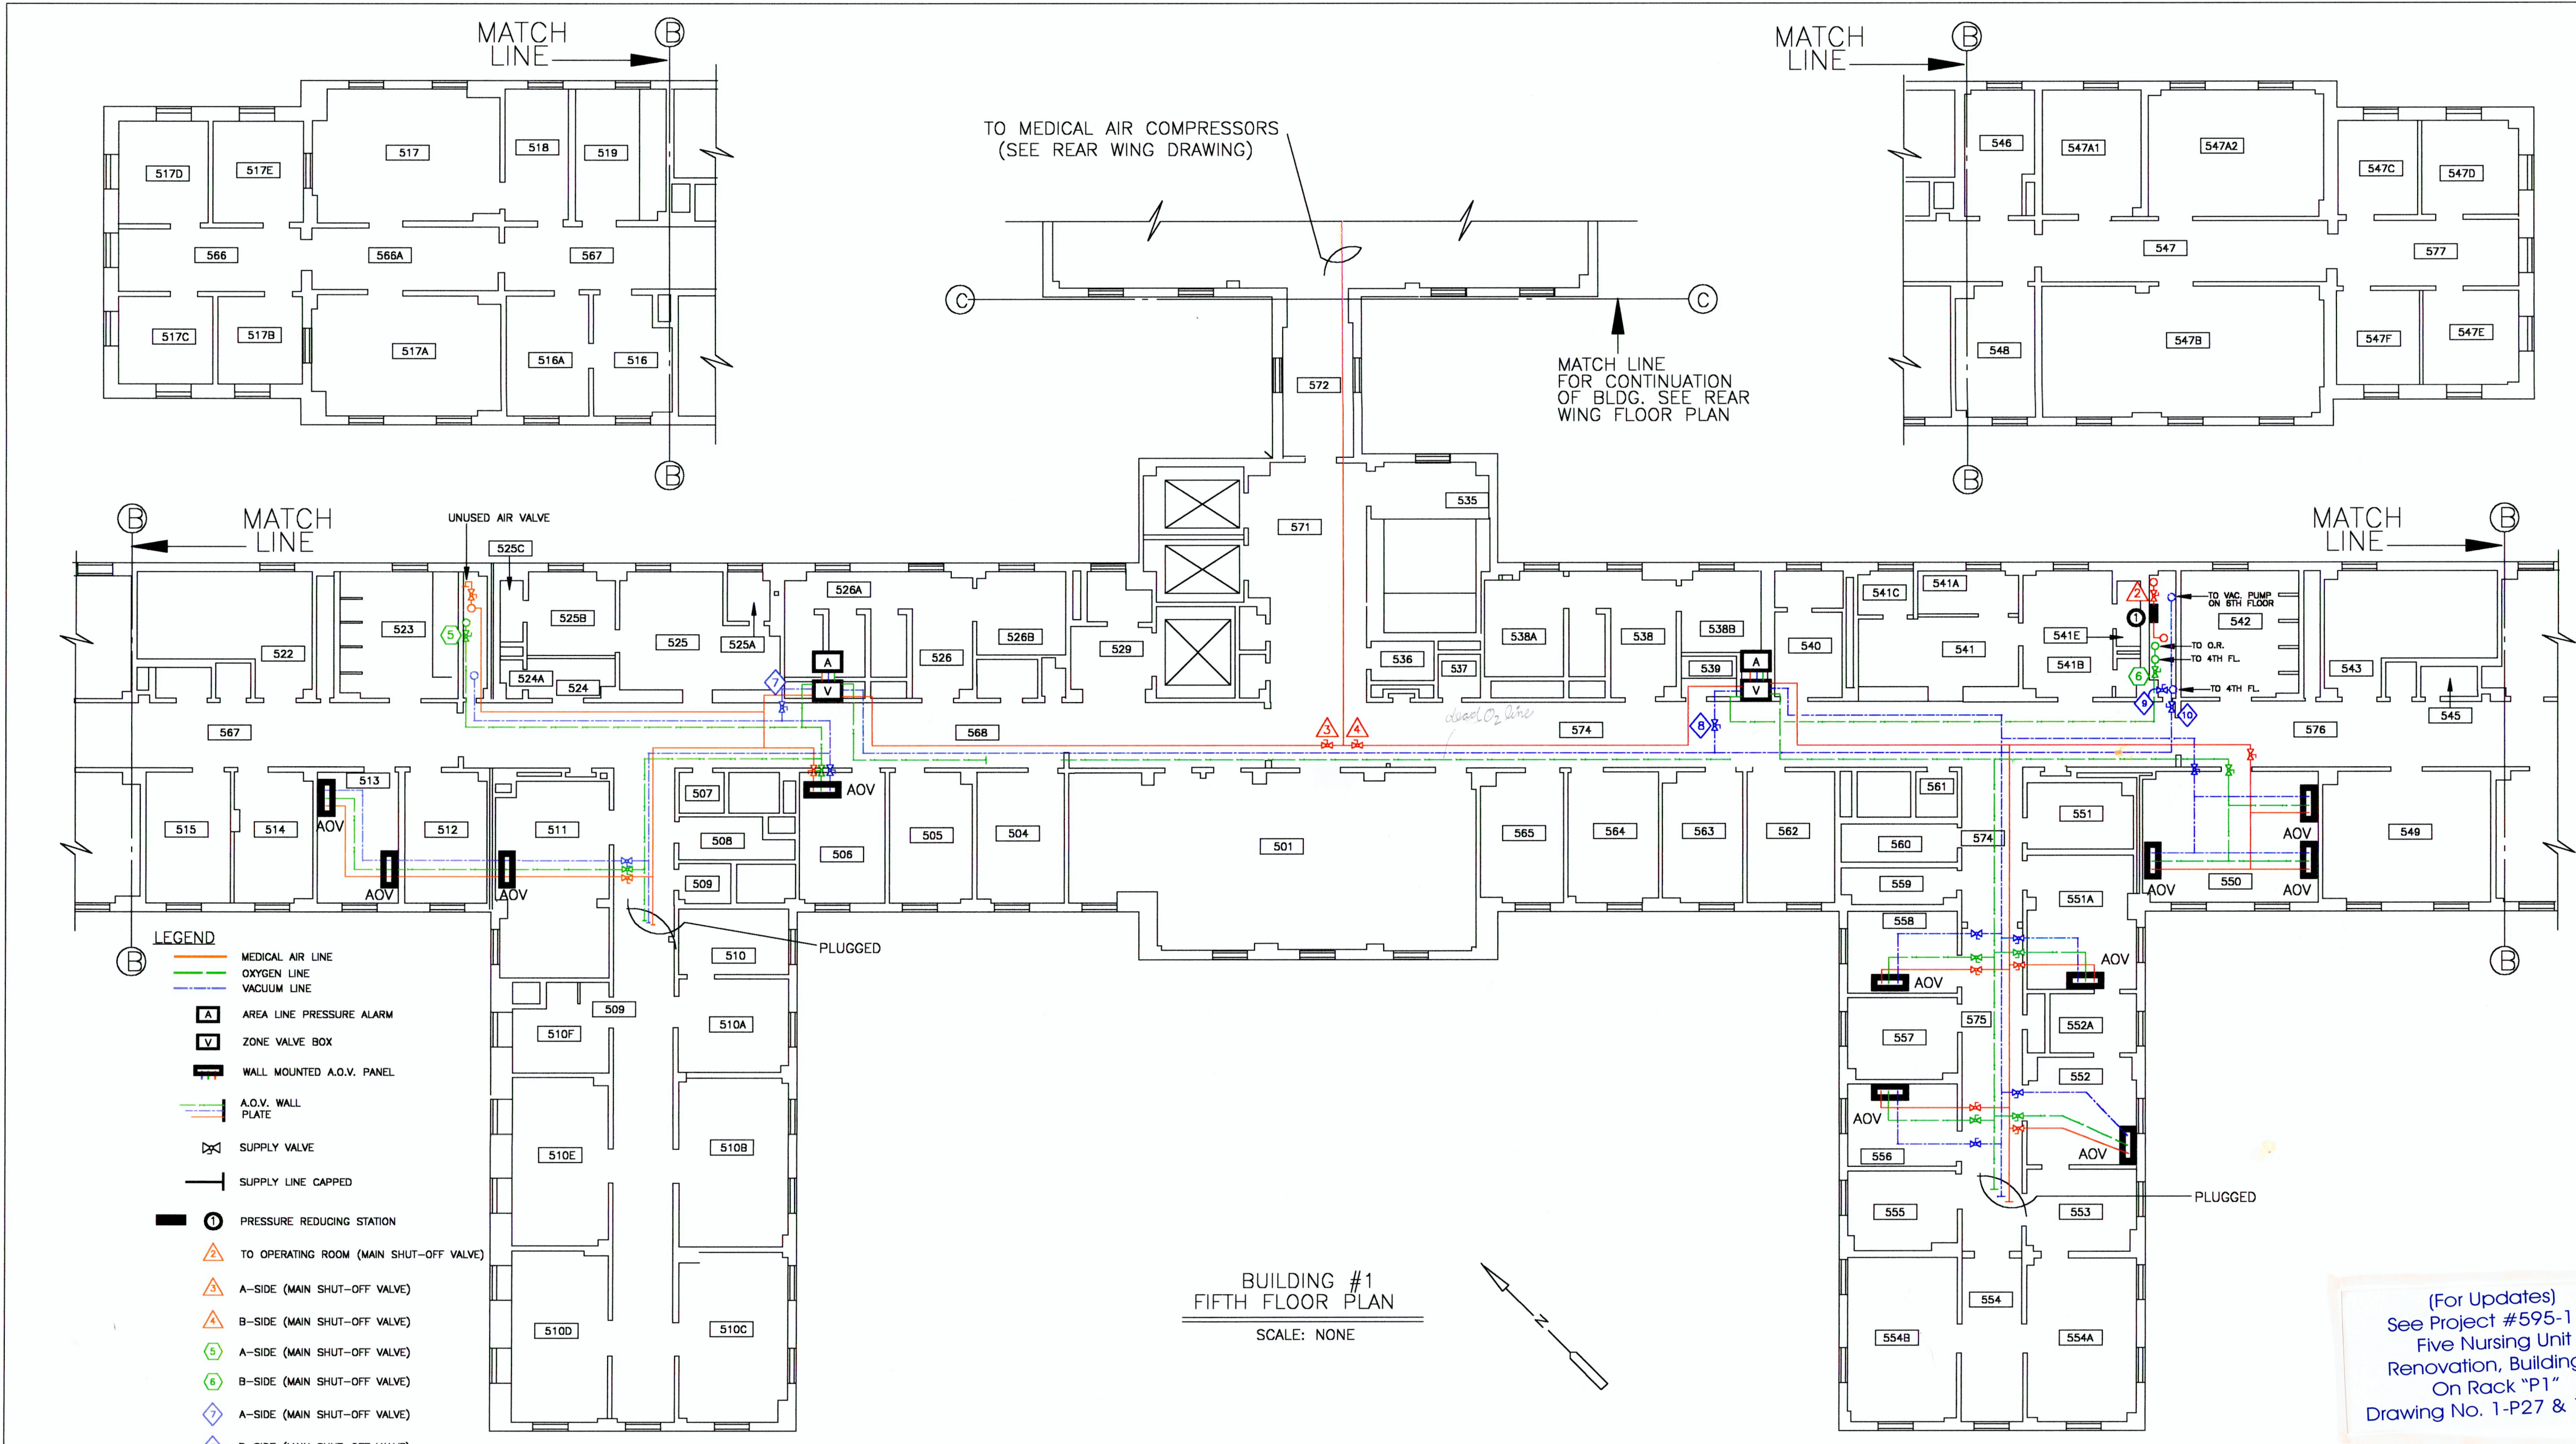

- LEGEND**
- MEDICAL AIR LINE
 - OXYGEN LINE
 - VACUUM LINE
 - [A] AREA LINE PRESSURE ALARM
 - [V] ZONE VALVE BOX
 - [] WALL MOUNTED A.O.V. PANEL
 - [] A.O.V. WALL PLATE
 - [] SUPPLY VALVE
 - [] SUPPLY LINE CAPPED
 - [] PRESSURE REDUCING STATION
 - [] TO OPERATING ROOM (MAIN SHUT-OFF VALVE)
 - [] A-SIDE (MAIN SHUT-OFF VALVE)
 - [] B-SIDE (MAIN SHUT-OFF VALVE)
 - [] A-SIDE (MAIN SHUT-OFF VALVE)
 - [] B-SIDE (MAIN SHUT-OFF VALVE)
 - [] A-SIDE (MAIN SHUT-OFF VALVE)
 - [] B-SIDE (MAIN SHUT-OFF VALVE)
 - [] B-SIDE (MAIN SHUT-OFF VALVE TO 1B, 2B, 3B, 4B)
 - [] B-SIDE (MAIN SHUT-OFF VALVE TO 1A, 2A, 3A, 4A, 5A, 5B)

BUILDING #1
FIFTH FLOOR PLAN
SCALE: NONE

(For Updates)
See Project #595-118
Five Nursing Unit
Renovation, Building 1
On Rack "P1"
Drawing No. 1-P27 & 1-P29

AS-BUILT

REVISIONS 1 ADD SHUTOFF VALVES PER RA/JK DATE: 2-12-98 RH	VERIFIED BY: MECHANICAL SYSTEMS FOREMAN BOB ADAMS	DATE: 1-21-97	APPROVED: Safety & Occupational Health Manager	APPROVED: Medical Center Director	Drawing Title FIFTH FLOOR PLAN	Project Title AIR, OXYGEN & VACUUM LINE LOCATIONS	Date 2/24/97	
			APPROVED: Chief, Environmental Management Service	APPROVED: Associate Medical Center Director	APPROVED: Project Section	Building Number 1	Project No.	
			APPROVED:	APPROVED: Chief of Staff	APPROVED: Chief, Engineering Service	Checked J.Bowers	Drawn R.D.Houtz	Drawing No. 1-7
			APPROVED:	APPROVED: Chief, Nursing Service	APPROVED: Chief, Engineering Service	Location VETERANS AFFAIRS MEDICAL CENTER LEBANON, PENNSYLVANIA		Dwg. 7 Of 10



BUILDING #1 REAR WING
THIRD FLOOR PLAN
SCALE: NONE


BUILDING #1 REAR WING
FOURTH FLOOR PLAN
SCALE: NONE

BUILDING #1 REAR WING
FIFTH FLOOR PLAN
SCALE: NONE

AS-BUILT

REVISIONS	DATE:	VERIFIED BY: MECHANICAL SYSTEMS FOREMAN BOB ADAMS	DATE: 1-21-97	APPROVED: Safety & Occupational Health Manager	APPROVED: Medical Center Director	Drawing Title THIRD, FOURTH, FIFTH ANNEX. FLOOR PLANS	Project Title AIR, OXYGEN & VACUUM LINE LOCATION		Date 2/24/97	
				APPROVED: Chief, Environmental Management Service	APPROVED: Associate Medical Center Director		Project No.			
				APPROVED:	APPROVED: Chief of Staff		Building Number 1	Checked J.Bowers	Drawn R.D.Houtz	Drawing No. 1-8
				APPROVED:	APPROVED: Chief, Nursing Service		APPROVED: Chief, Engineering Service	Location VETERANS AFFAIRS MEDICAL CENTER LEBANON, PENNSYLVANIA		Dwg. 8 of 10

1ADV4ANN

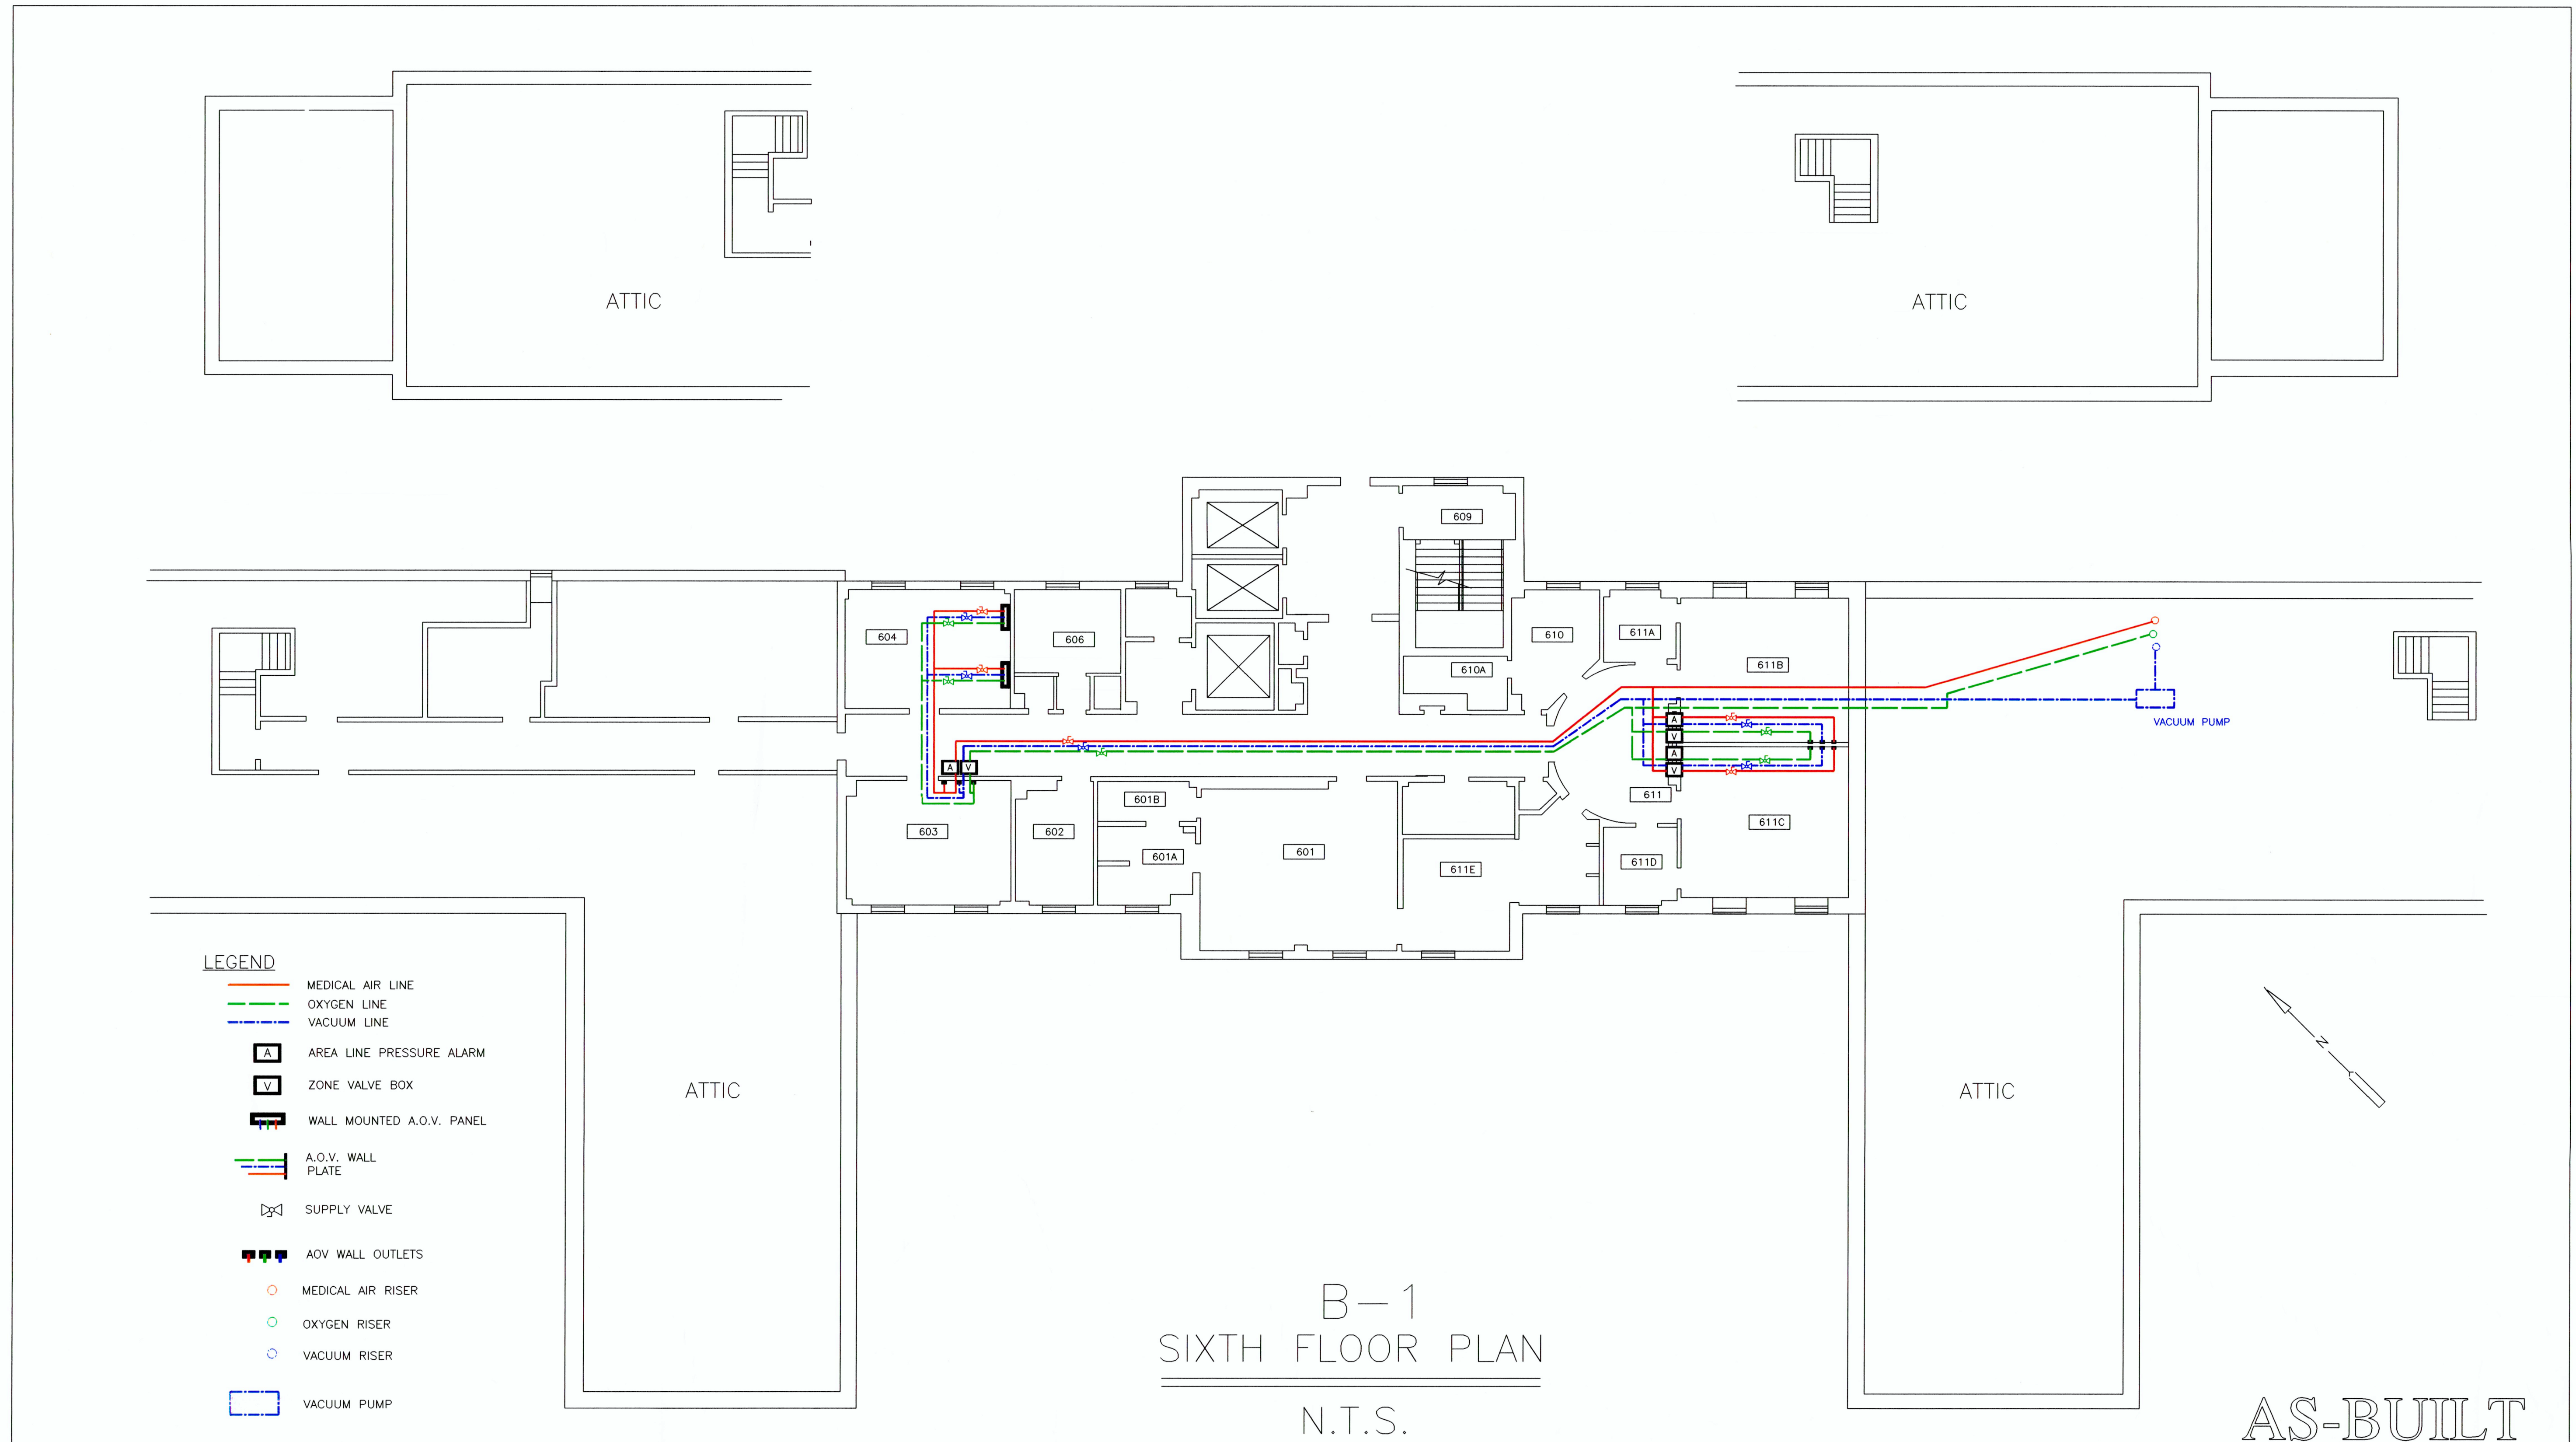


LEGEND

- MEDICAL AIR LINE
- OXYGEN LINE
- VACUUM LINE
- A AREA LINE PRESSURE ALARM
- V ZONE VALVE BOX
- WALL MOUNTED A.O.V. PANEL
- A.O.V. WALL PLATE
- SUPPLY VALVE
- A.O.V. WALL OUTLETS
- MEDICAL AIR RISER
- OXYGEN RISER
- VACUUM RISER
- VACUUM PUMP

B-1
SIXTH FLOOR PLAN
N.T.S.

AS-BUILT

				APPROVED: Safety & Occupational Health Manager	APPROVED: Medical Center Director	Drawing Title	Project Title	Date
				APPROVED: Chief, Environmental Management Service	APPROVED: Associate Medical Center Director	SIXTH FLOOR PLAN	AIR, OXYGEN & VACUUM LINE LOCATIONS	2/20/97
				APPROVED:	APPROVED: Chief of Staff	APPROVED: Project Section	Building Number	Checked
REVISIONS	DATE:	VERIFIED BY: MECHANICAL SYSTEMS FOREMAN BOB ADAMS	DATE: 1-21-97	APPROVED:	APPROVED: Chief, Nursing Service	APPROVED: Chief, Engineering Service	1	J.Bowers
							Drawn	Drawing No.
							R.D.Houtz	1-9
							Location	Dwg. 9 Of 10
							VETERANS AFFAIRS MEDICAL CENTER LEBANON, PENNSYLVANIA	

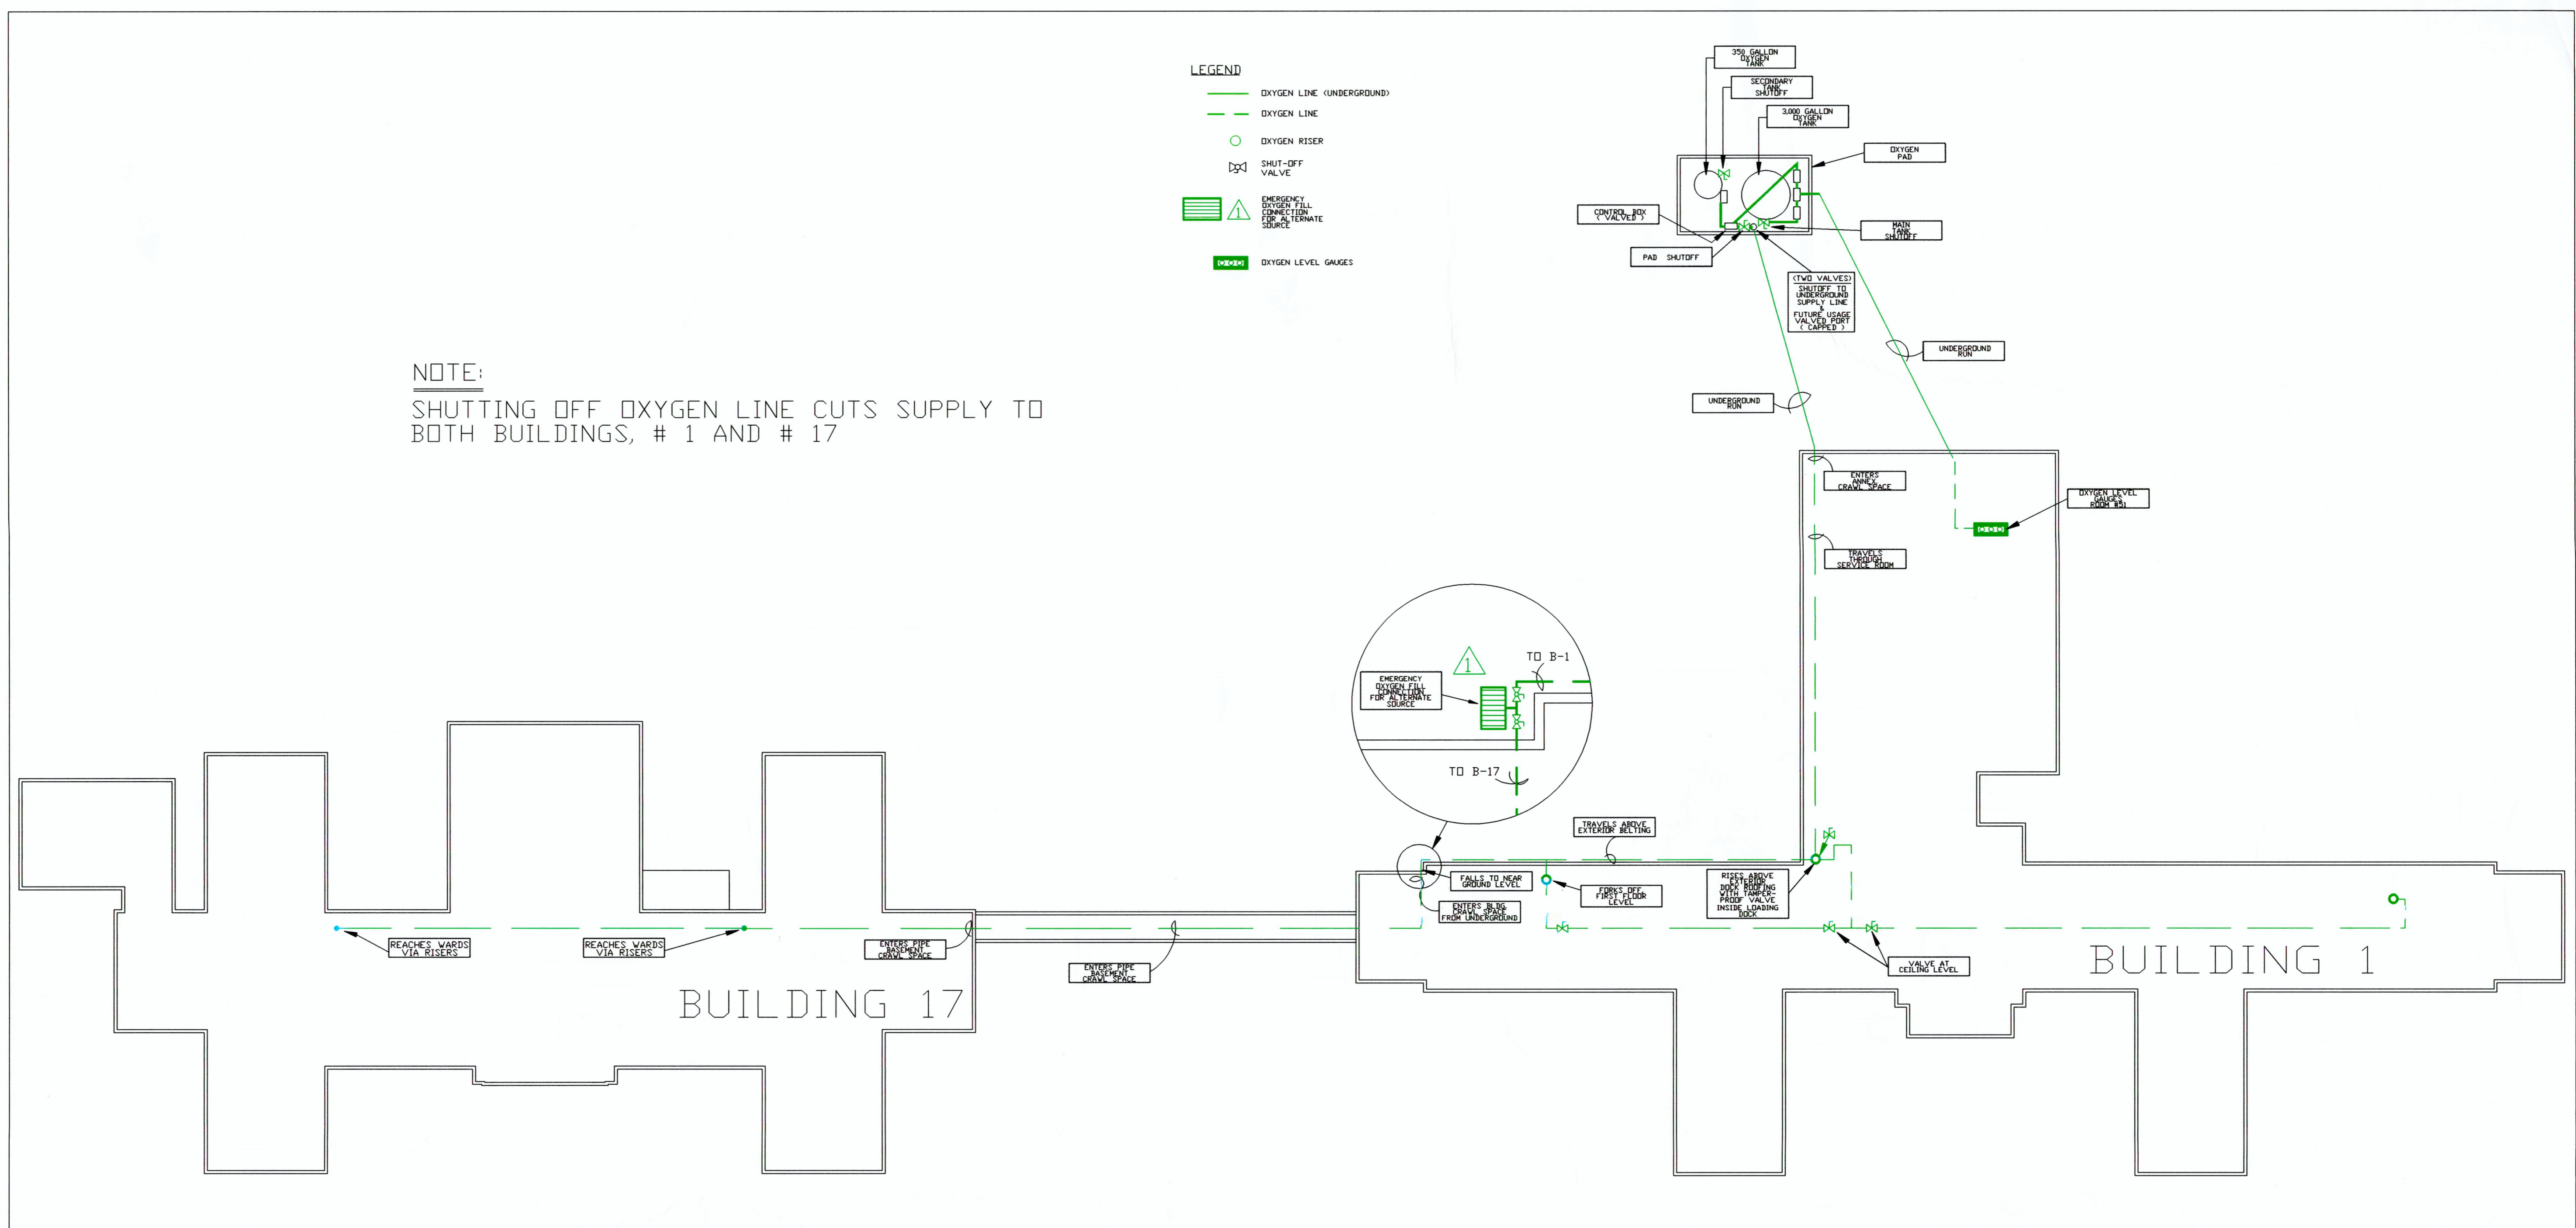

NOTE:
SHUTTING OFF OXYGEN LINE CUTS SUPPLY TO BOTH BUILDINGS, # 1 AND # 17

OXYGEN SUPPLY ROUTING

N.T.S.

AS-BUILT

DESUPPLX	REVISIONS	DATE:	VERIFIED BY: MECHANICAL SYSTEMS FOREMAN BOB ADAMS	DATE: 1-21-97	APPROVED: Safety & Occupational Health Manager	APPROVED: Medical Center Director	Drawing Title BLDG. 1 AND 17 FLOOR PLANS	Project Title OXYGEN SUPPLY ROUTING	Date 2/6/97
					APPROVED: Chief, Environmental Management Service	APPROVED: Associate Medical Center Director	APPROVED: Project Section	Building Number 1 AND 17	Project No.
					APPROVED:	APPROVED: Chief of Staff	APPROVED: Chief, Engineering Service	Checked R.D.Houtz	Drawing No. 1/17-10
					APPROVED:	APPROVED: Chief, Nursing Service	Location VETERANS AFFAIRS MEDICAL CENTER LEBANON, PENNSYLVANIA	Drawn R.D.Houtz	Dwg. 10 OF 10